




Drawings Set


PROPOSED AUTOMATED MULTI LEVEL CAR PARKING AT KACHERIPADY KOCHIN KERALA			
<u>SURVEY PLAN</u>			
<u>S.NO.</u>	<u>DRAWING TITLE</u>	<u>DRAWING NO.</u>	<u>REMARK</u>
1	SURVEY PLAN	NHIDCL/AMLCP/KPDY/A/SL-01	
2	SITE PLAN	NHIDCL/AMLCP/KPDY/A/L-01	
<u>ARCHITECTURAL DRAWINGS (FLOOR PLANS)</u>			
1	UNDER GROUND FIRE TANK LIFT PIT LAYOUT PLAN	NHIDCL/AMLCP/KPDY/A/A1-01	LIFT PIT,PUMP ROOM
2	GROUND FLOOR PLAN	NHIDCL/AMLCP/KPDY/A/A1-02	ENTRY AND EXIT
3	FIRST FLOOR PLAN	NHIDCL/AMLCP/KPDY/A/A1-03	FIRST FLOOR
4	SECOND (TYPICAL 2 ND TO 7 TH FLOOR)	NHIDCL/AMLCP/KPDY/A/A1-04	TYPICAL FLOORS
5	TERRACE PLAN	NHIDCL/AMLCP/KPDY/A/A1-05	TERRACE
6	SECTION 1	NHIDCL/AMLCP/KPDY/A/A3-01	SECTIONS

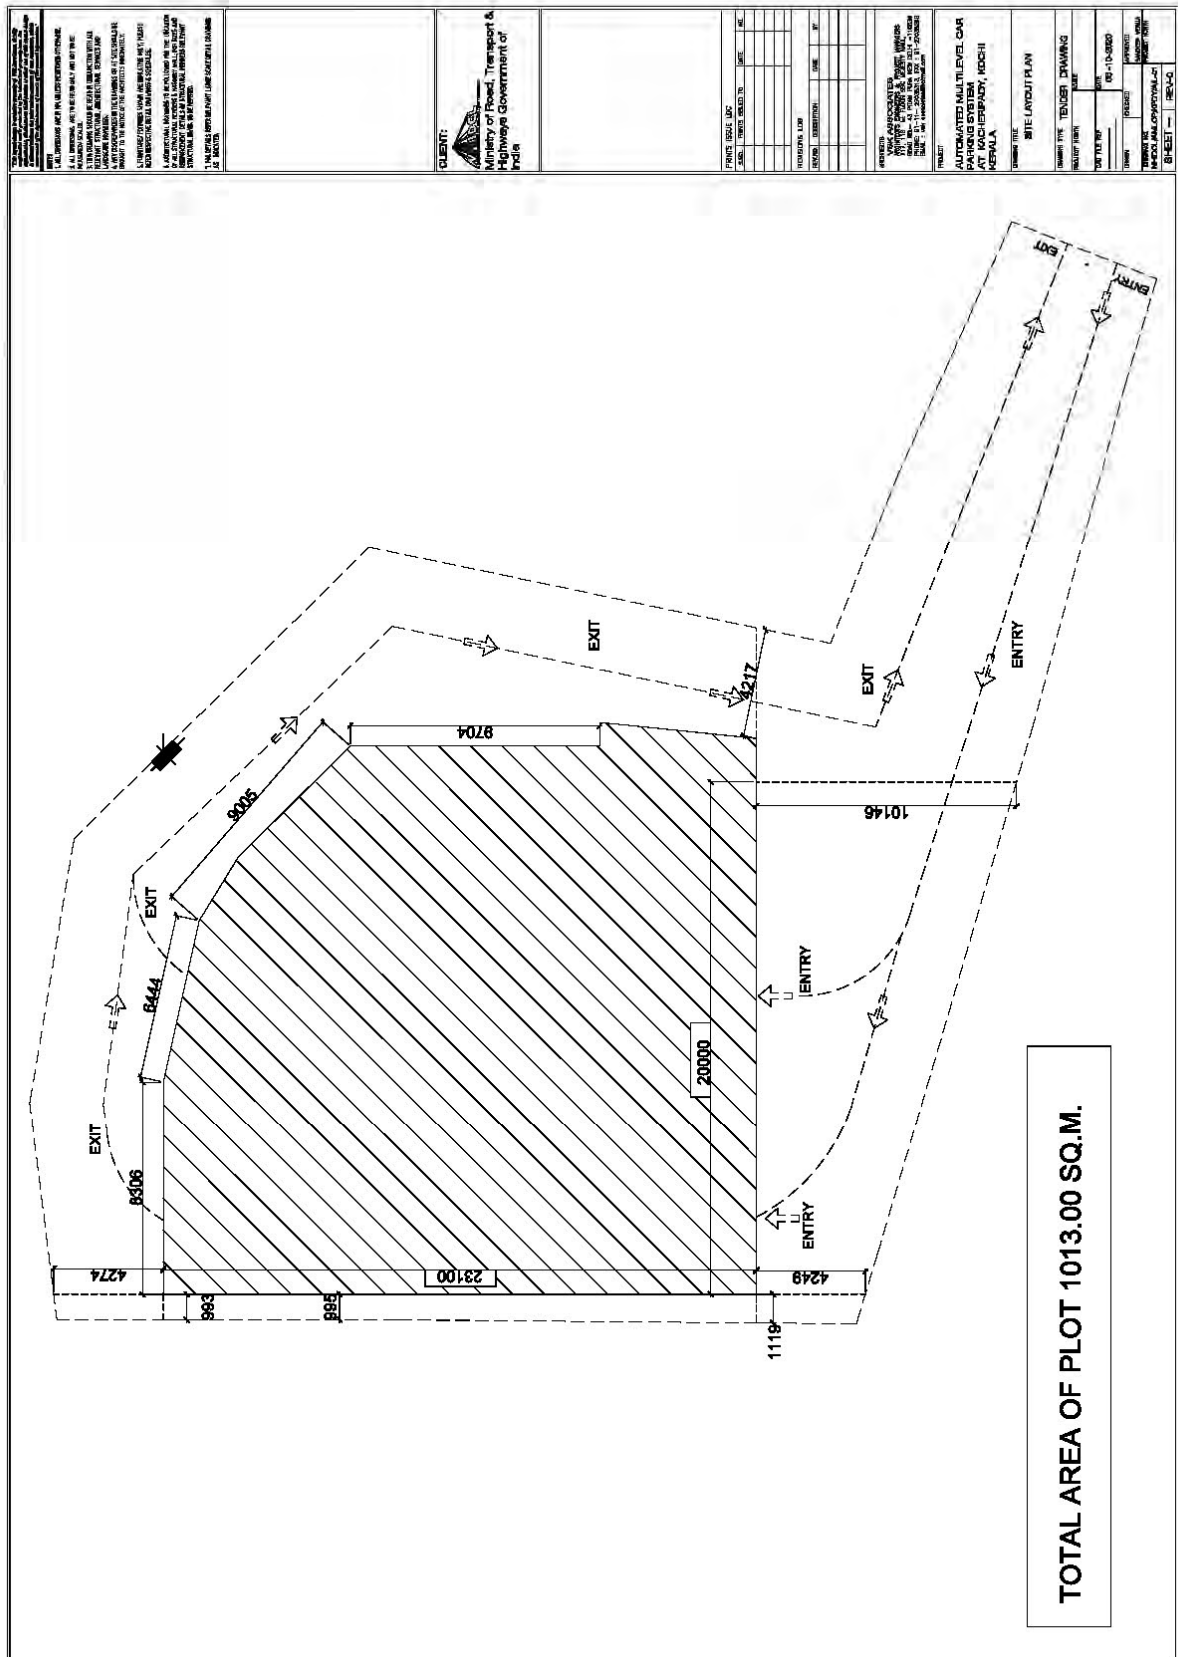


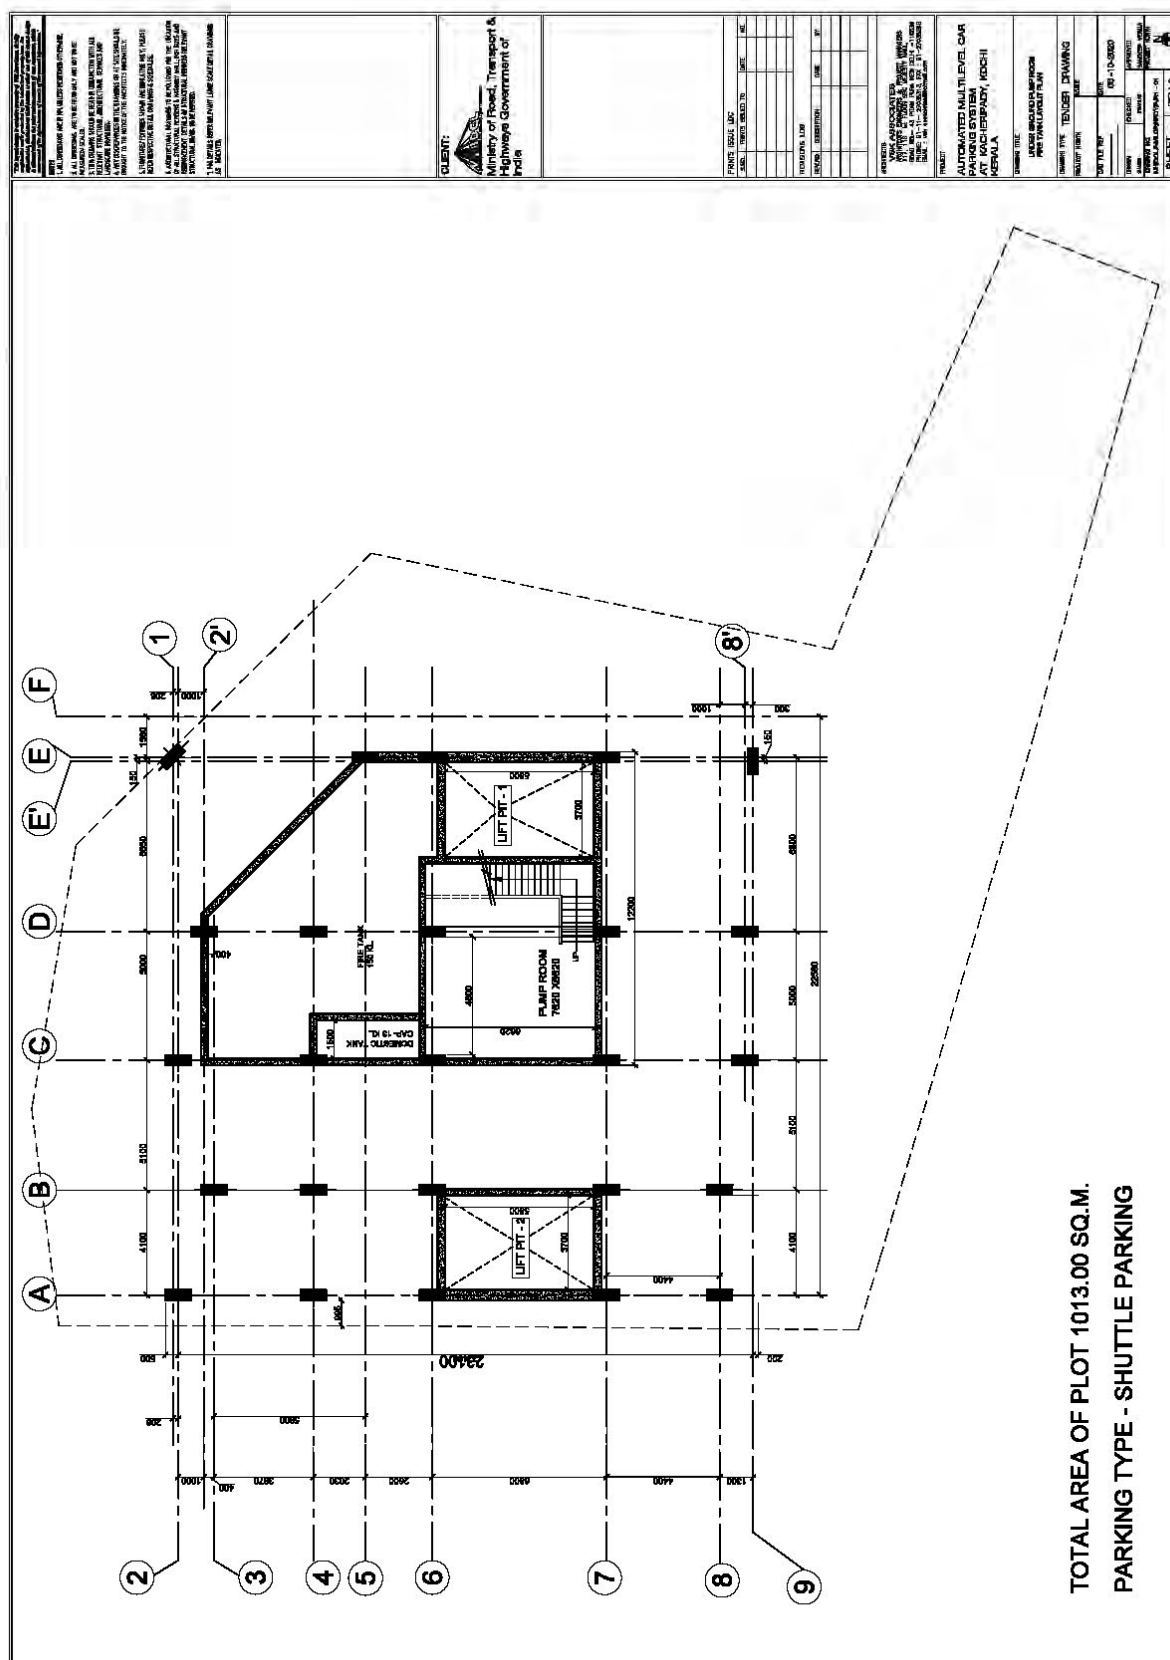





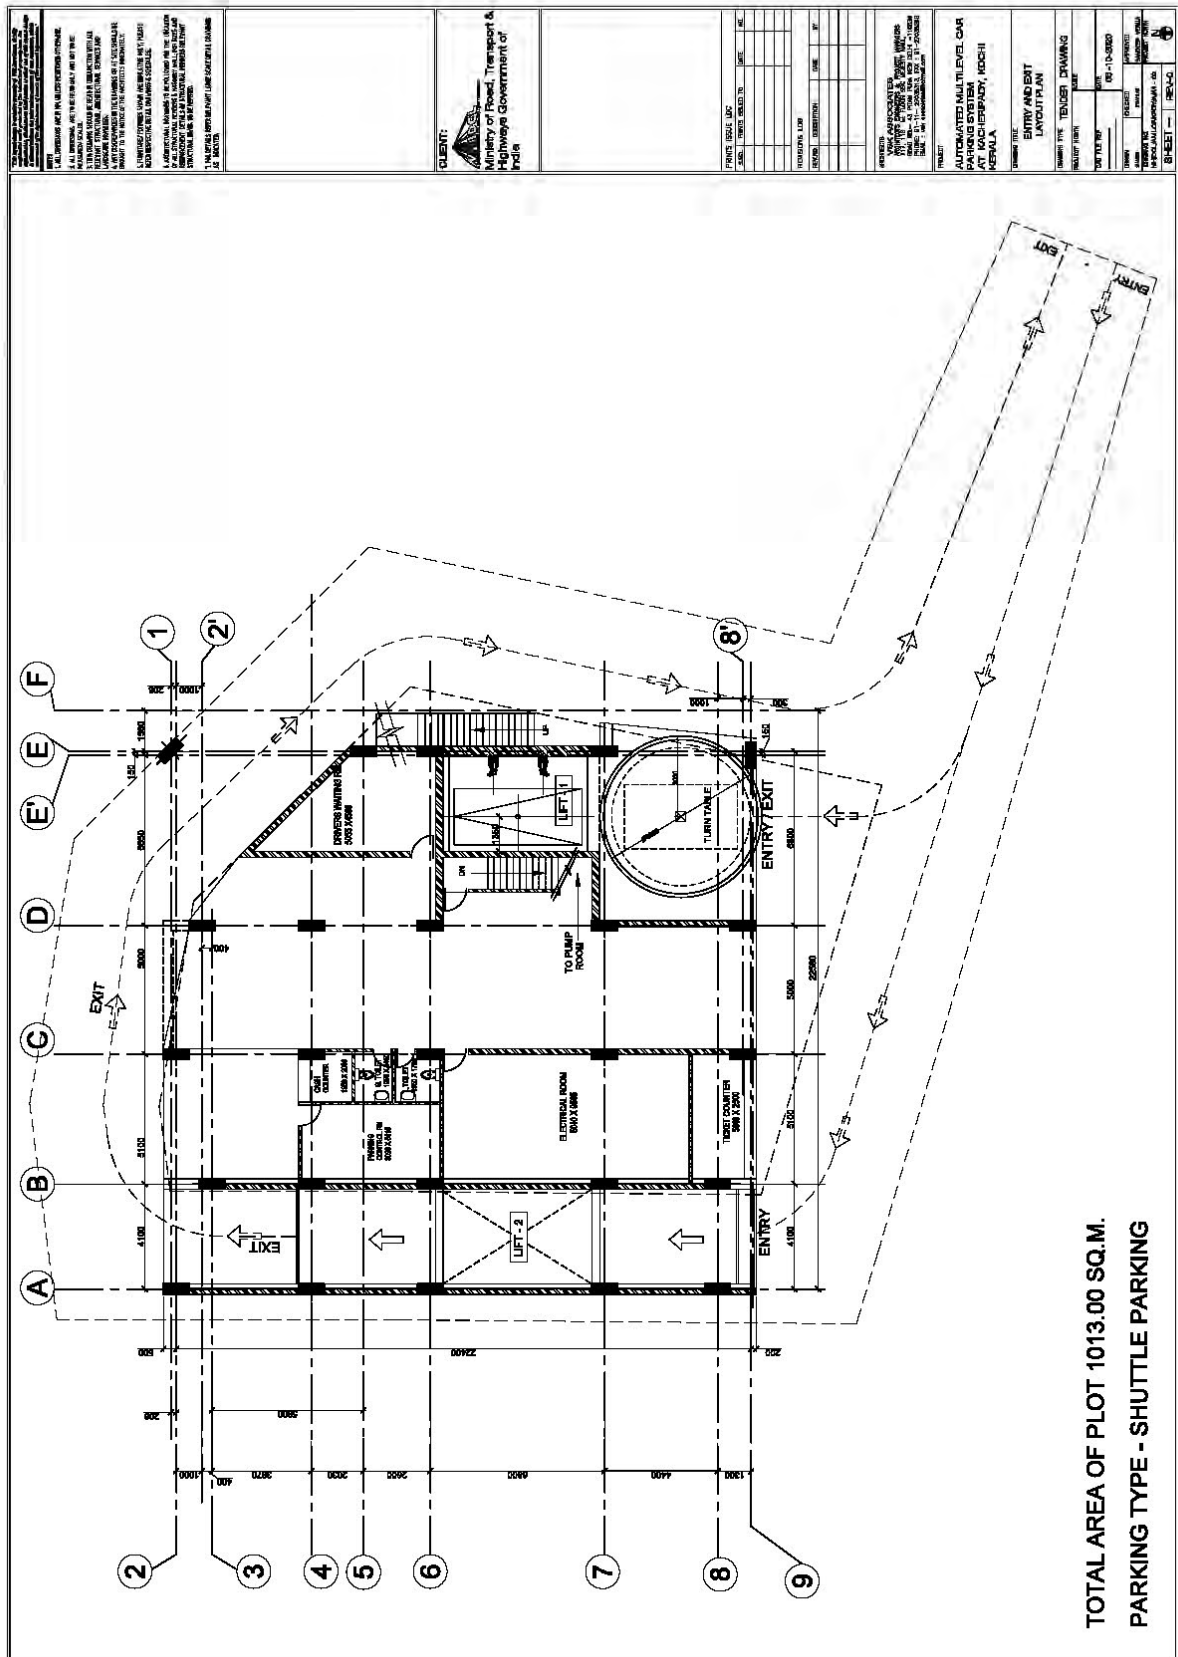

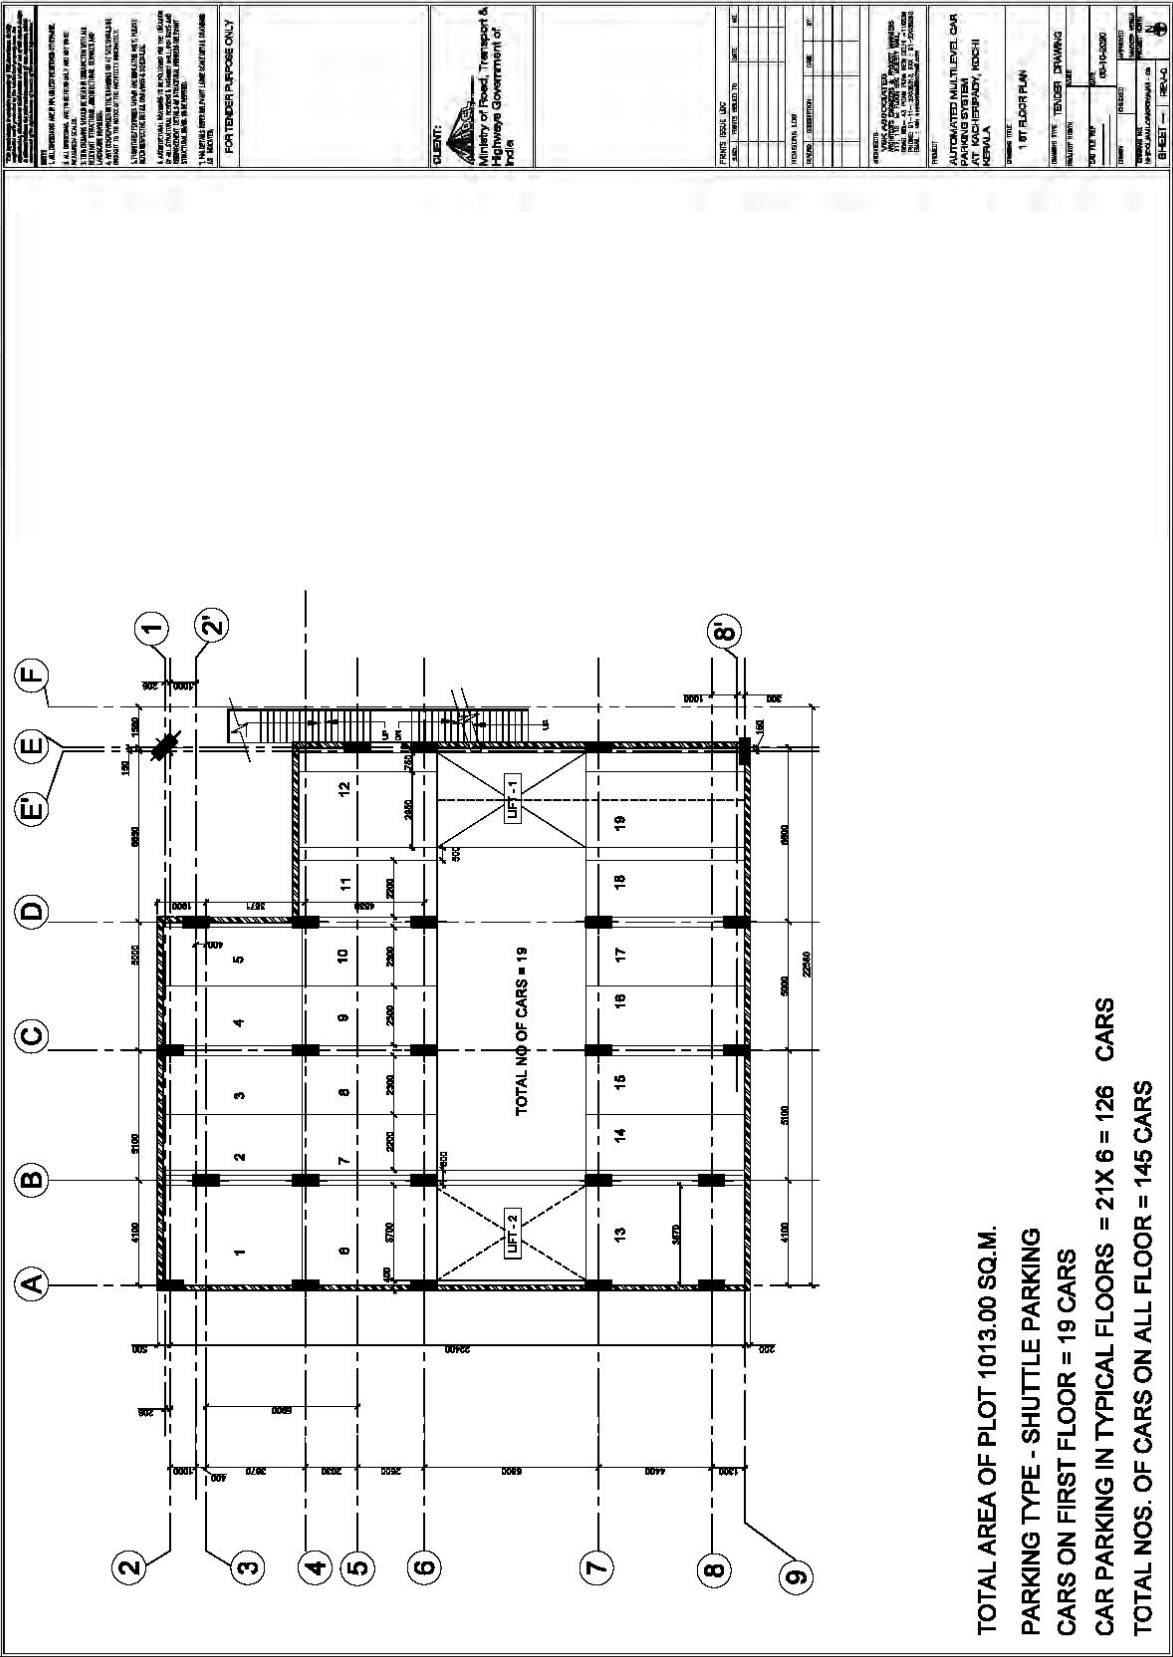


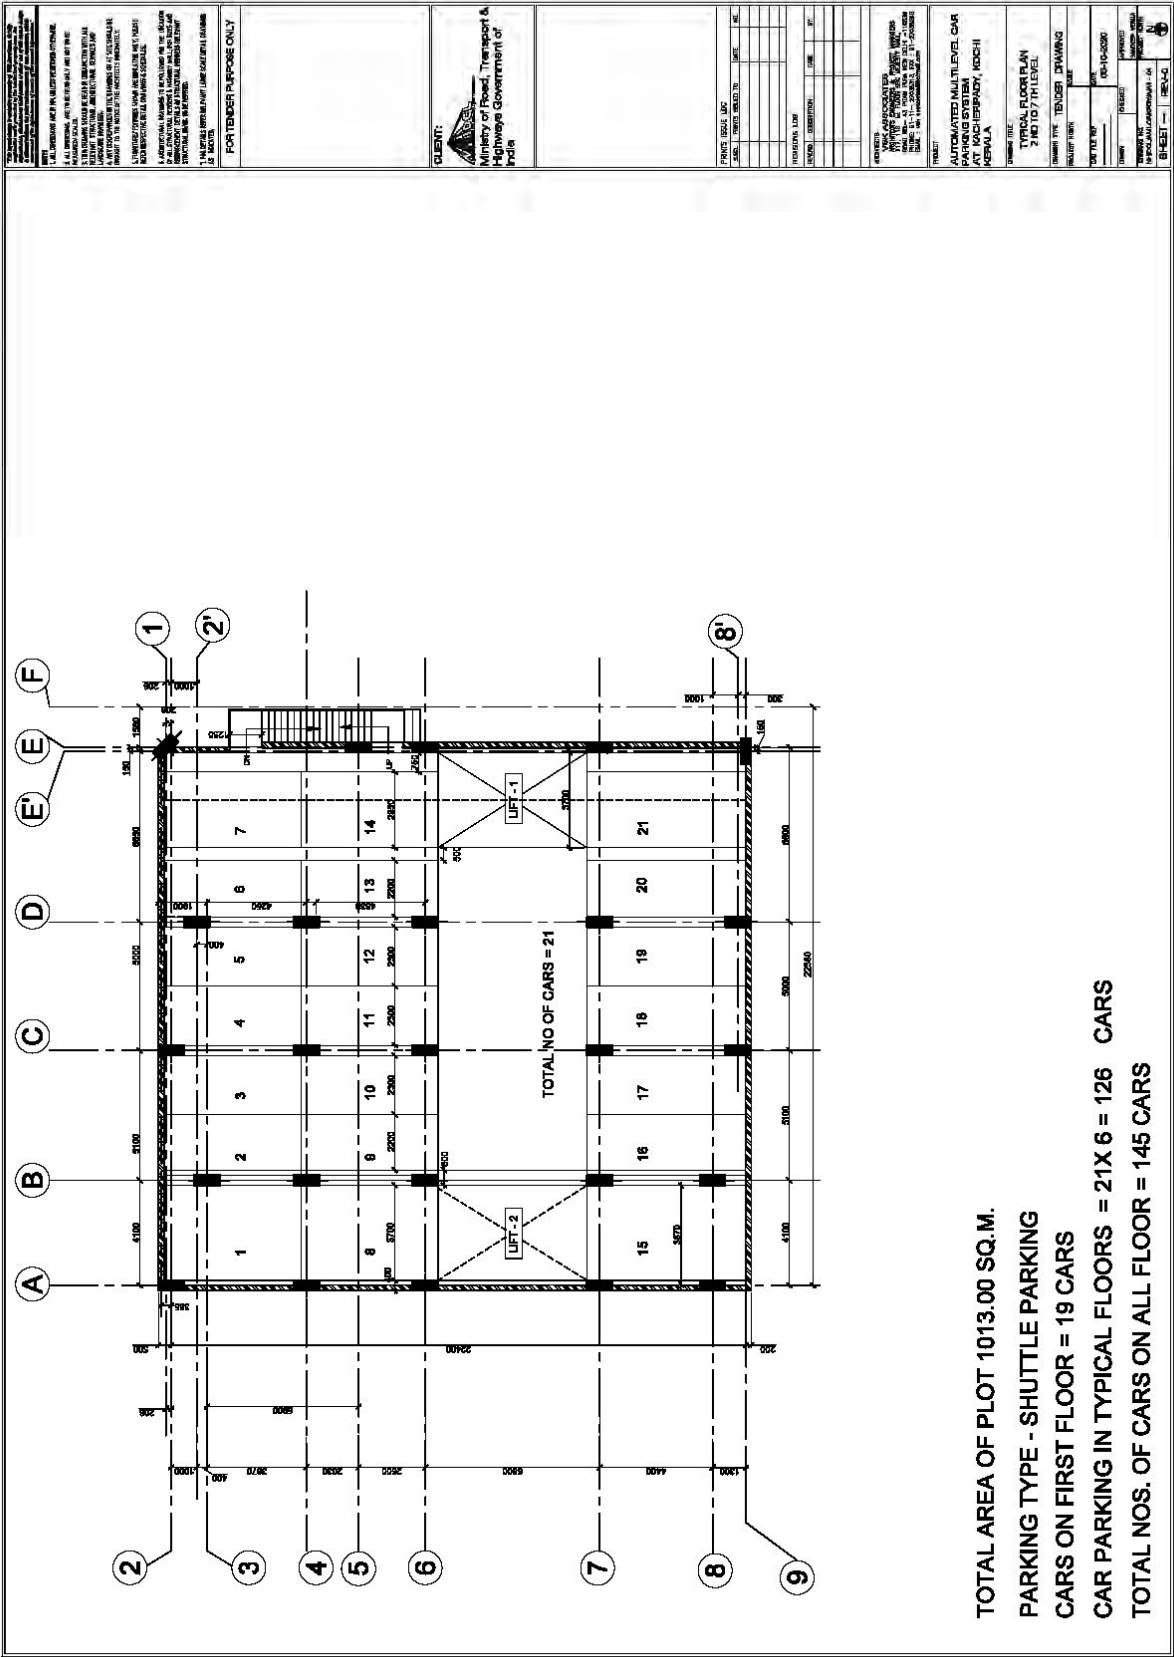


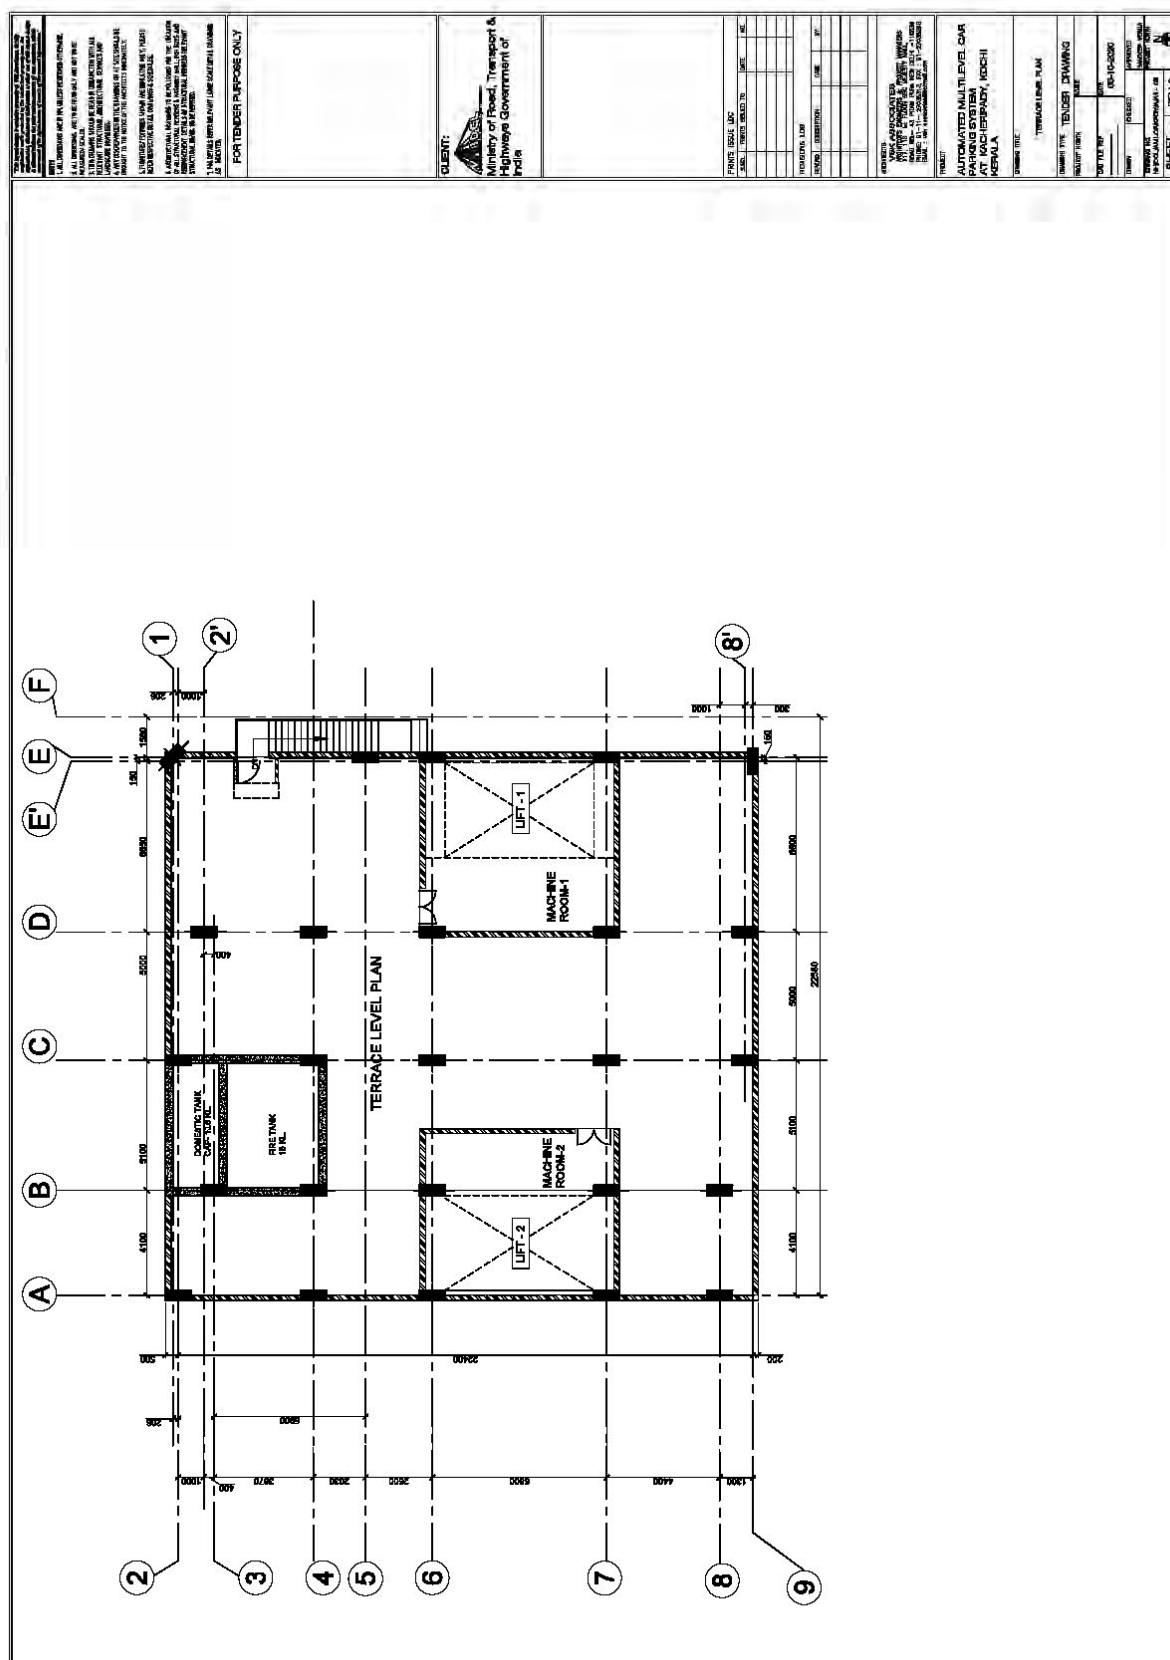


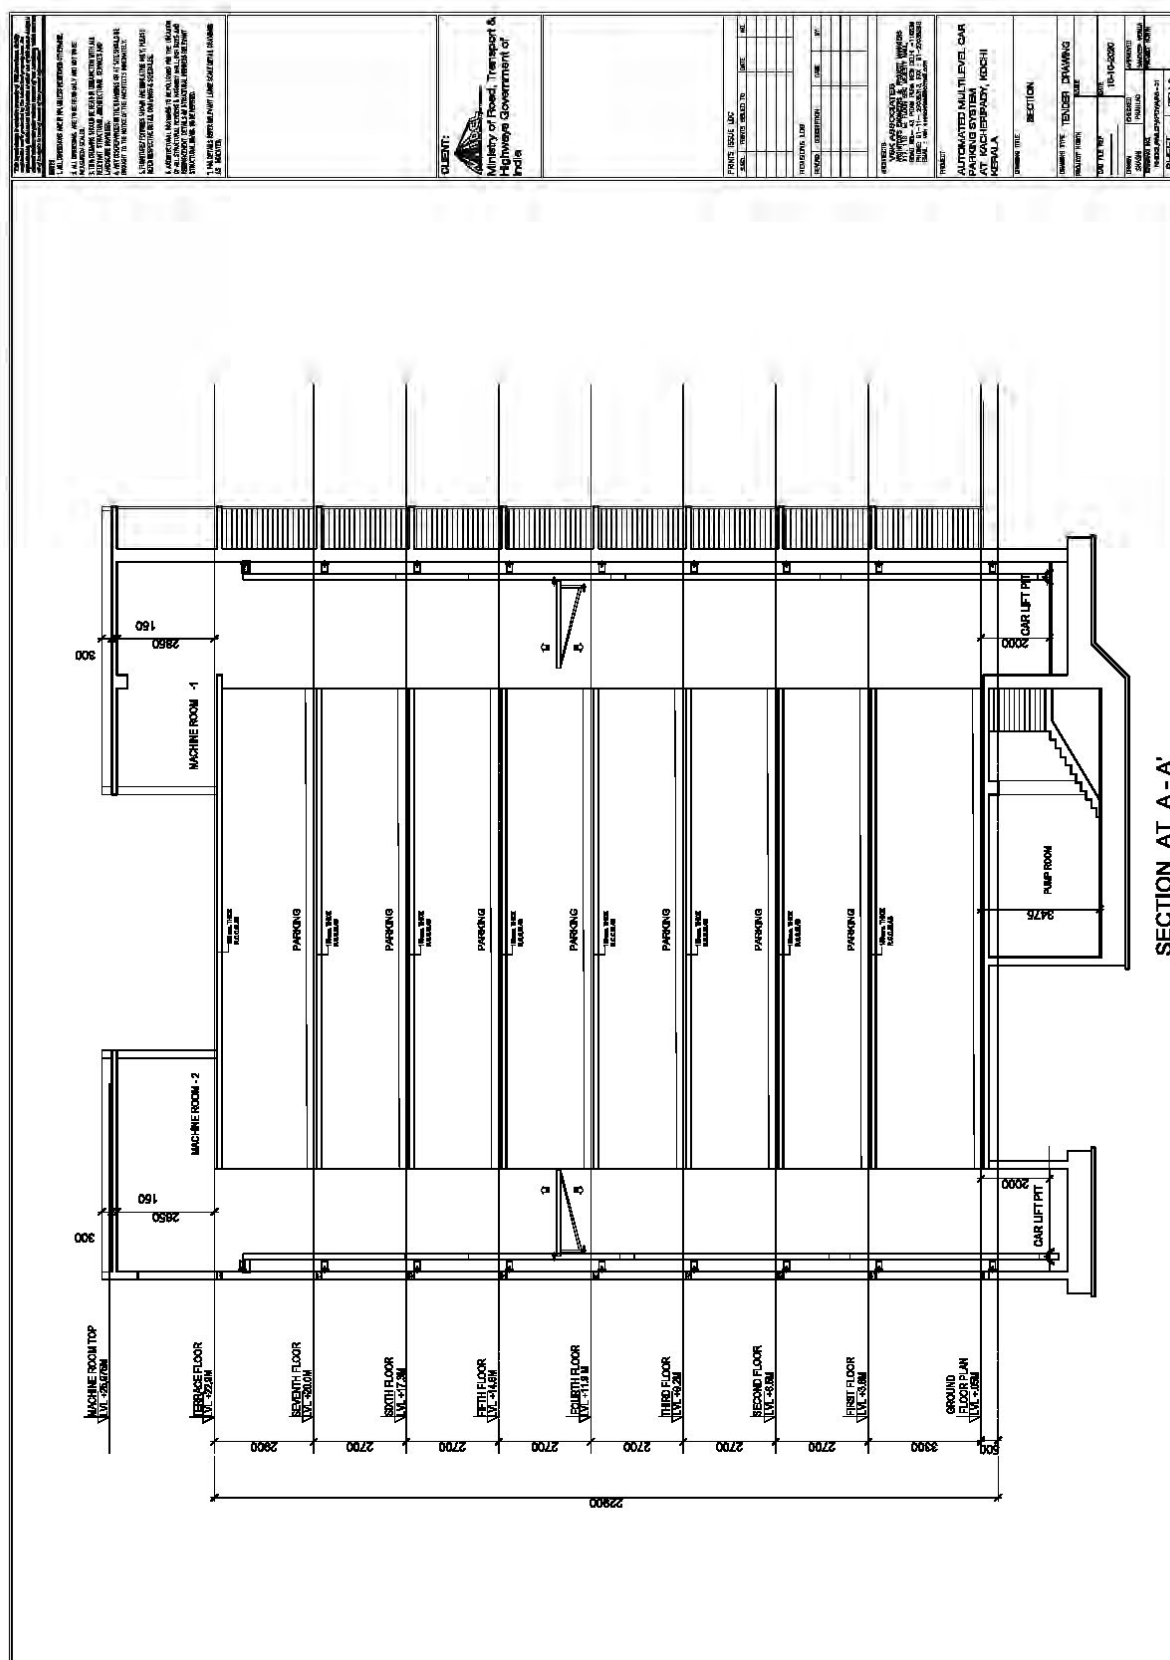



<u>PROPOSED AUTOMATED MULTI LEVEL CAR PARKING AT KACHERIPADY KOCHIN KERALA</u>			
<u>ELECTRICAL LAYOUT DRAWINGS (FLOOR PLANS)</u>			
<u>S.NO.</u>	<u>DRAWING TITLE</u>	<u>DRAWING NO.</u>	<u>REMARK</u>
1	UNDER GROUND FIRE TANK LIFT PIT LAYOUT PLAN	NHIDCL/AMLCP/KPDY/EL/A1-01	LIFT PIT,PUMP ROOM
2	ELECTRICAL LAYOUT GROUND FLOOR PLAN	NHIDCL/AMLCP/KPDY/EL/A1-02	ENTRY AND EXIT
3	ELECTRICAL LAYOUT FIRST FLOOR PLAN	NHIDCL/AMLCP/KPDY/EL/A1-03	FIRST FLOOR
4	ELECTRICAL LAYOUT 2 ND FLOOR TO 6 TH FLOOR	NHIDCL/AMLCP/KPDY/EL/A1-04	TYPICAL FLOORS
5	ELECTRICAL LAYOUT 7 TH FLOOR	NHIDCL/AMLCP/KPDY/EL/A1-05	7 TH FLOOR
6	ELECTRICAL LAYOUT TERRACE PLAN	NHIDCL/AMLCP/KPDY/EL/A1-06	TERRACE
7	ELECTRICAL SLD	NHIDCL/AMLCP/KPDY/EL/SLD-01	SLD-1
8	ELECTRICAL SLD	NHIDCL/AMLCP/KPDY/EL/SLD-02	SLD-2
9	SCHEMATIC DIAGRAM FOR FIRE DETECTION SYSTEM	NHIDCL/AMLCP/KPDY/EL/SLD-03	SLD-3

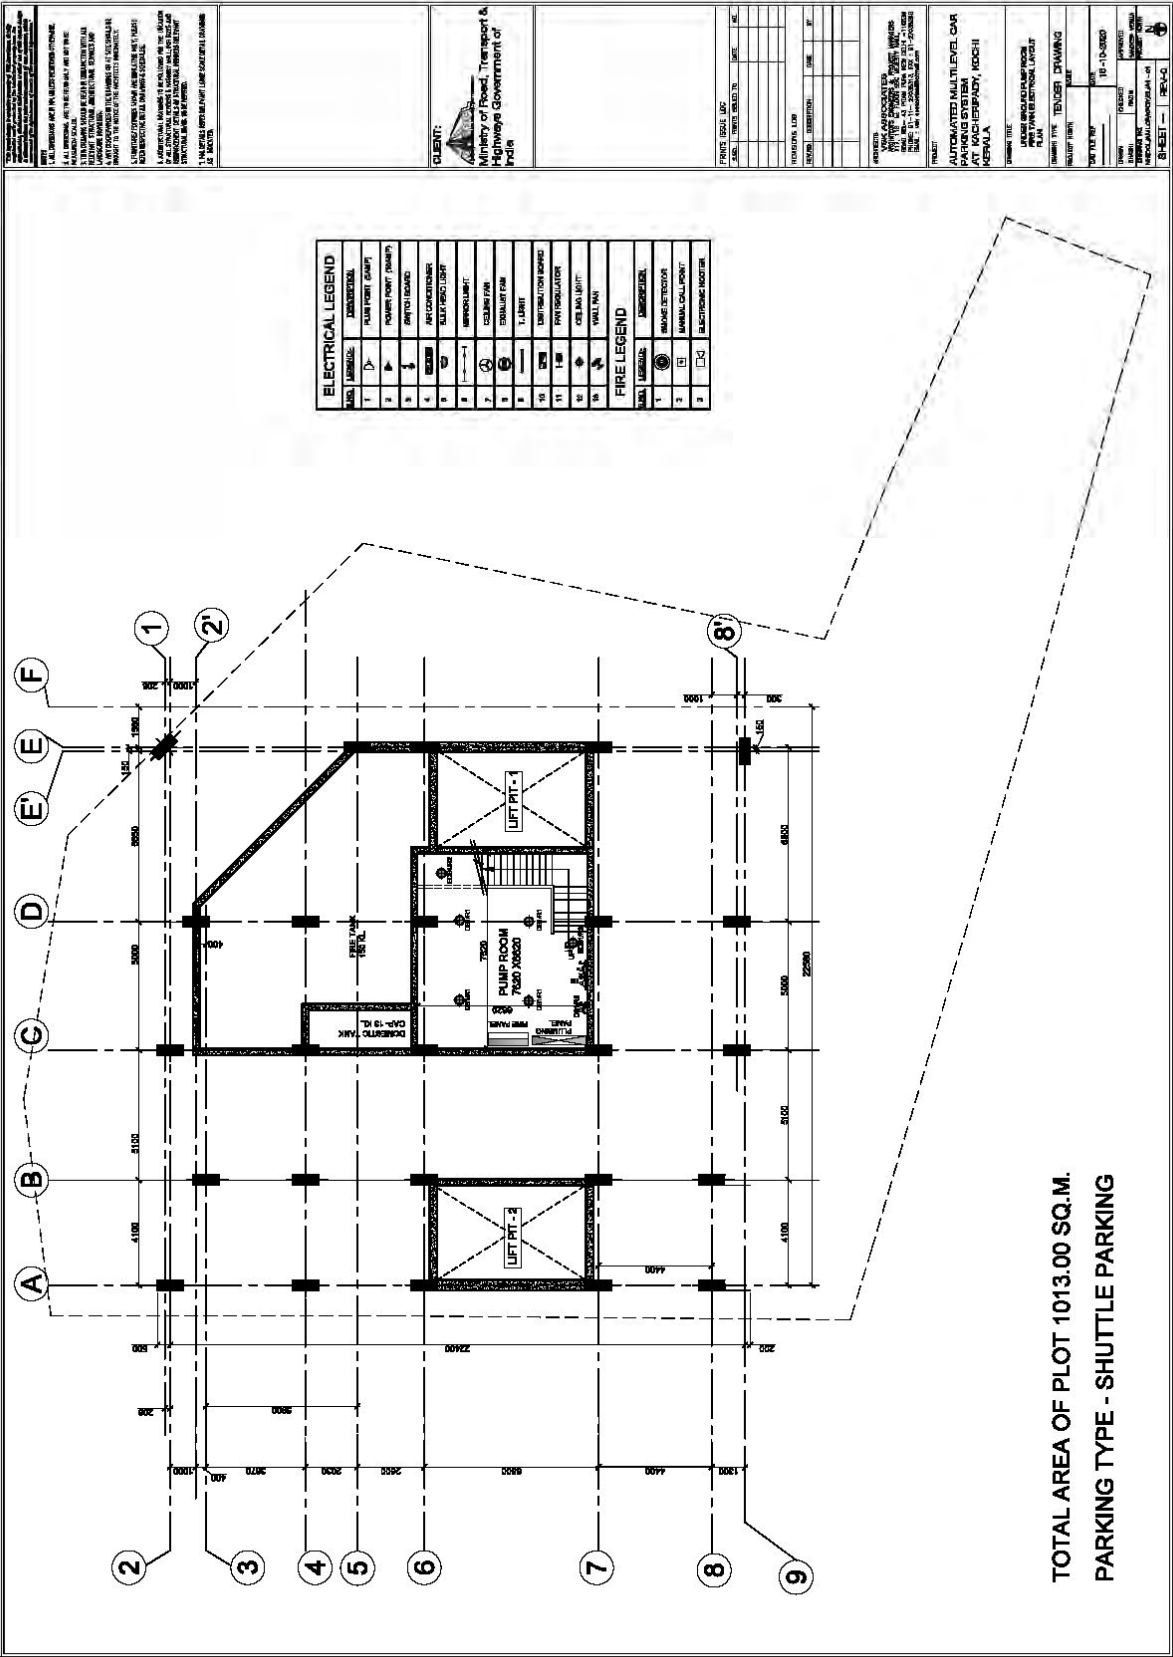


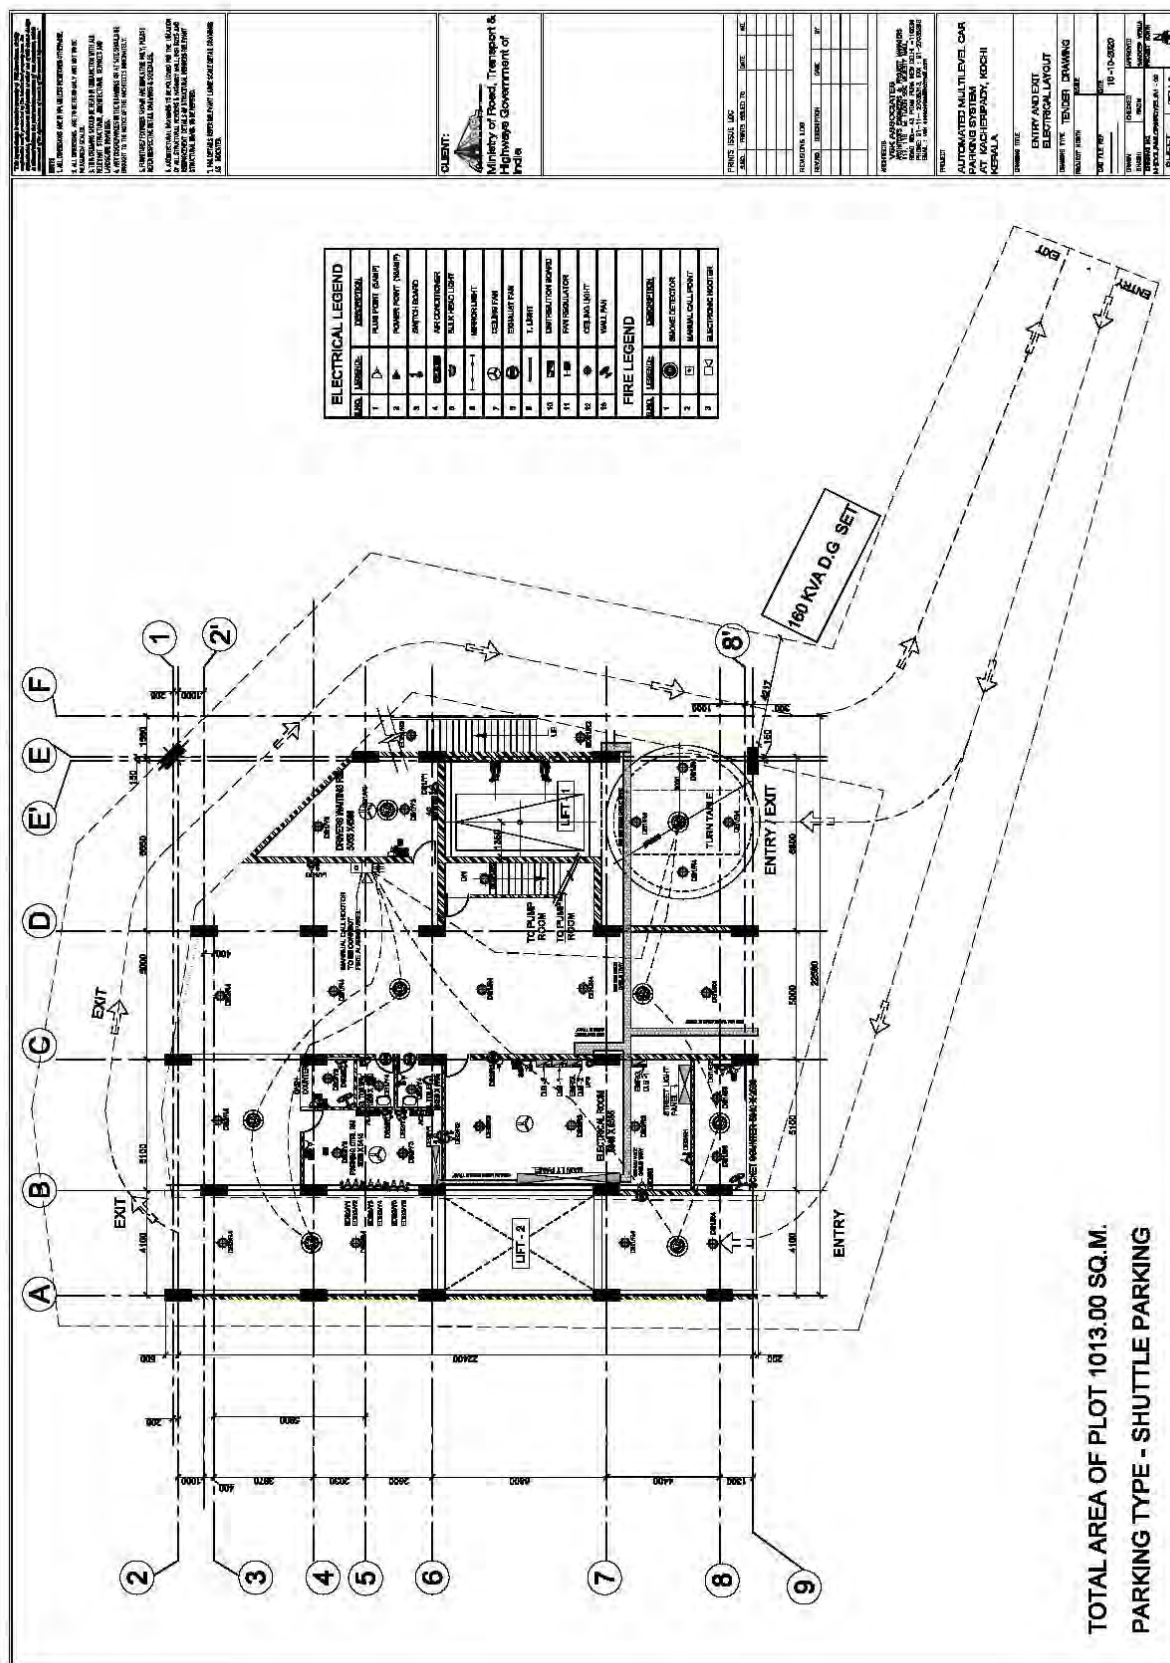


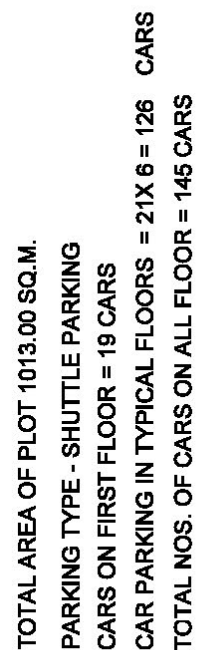


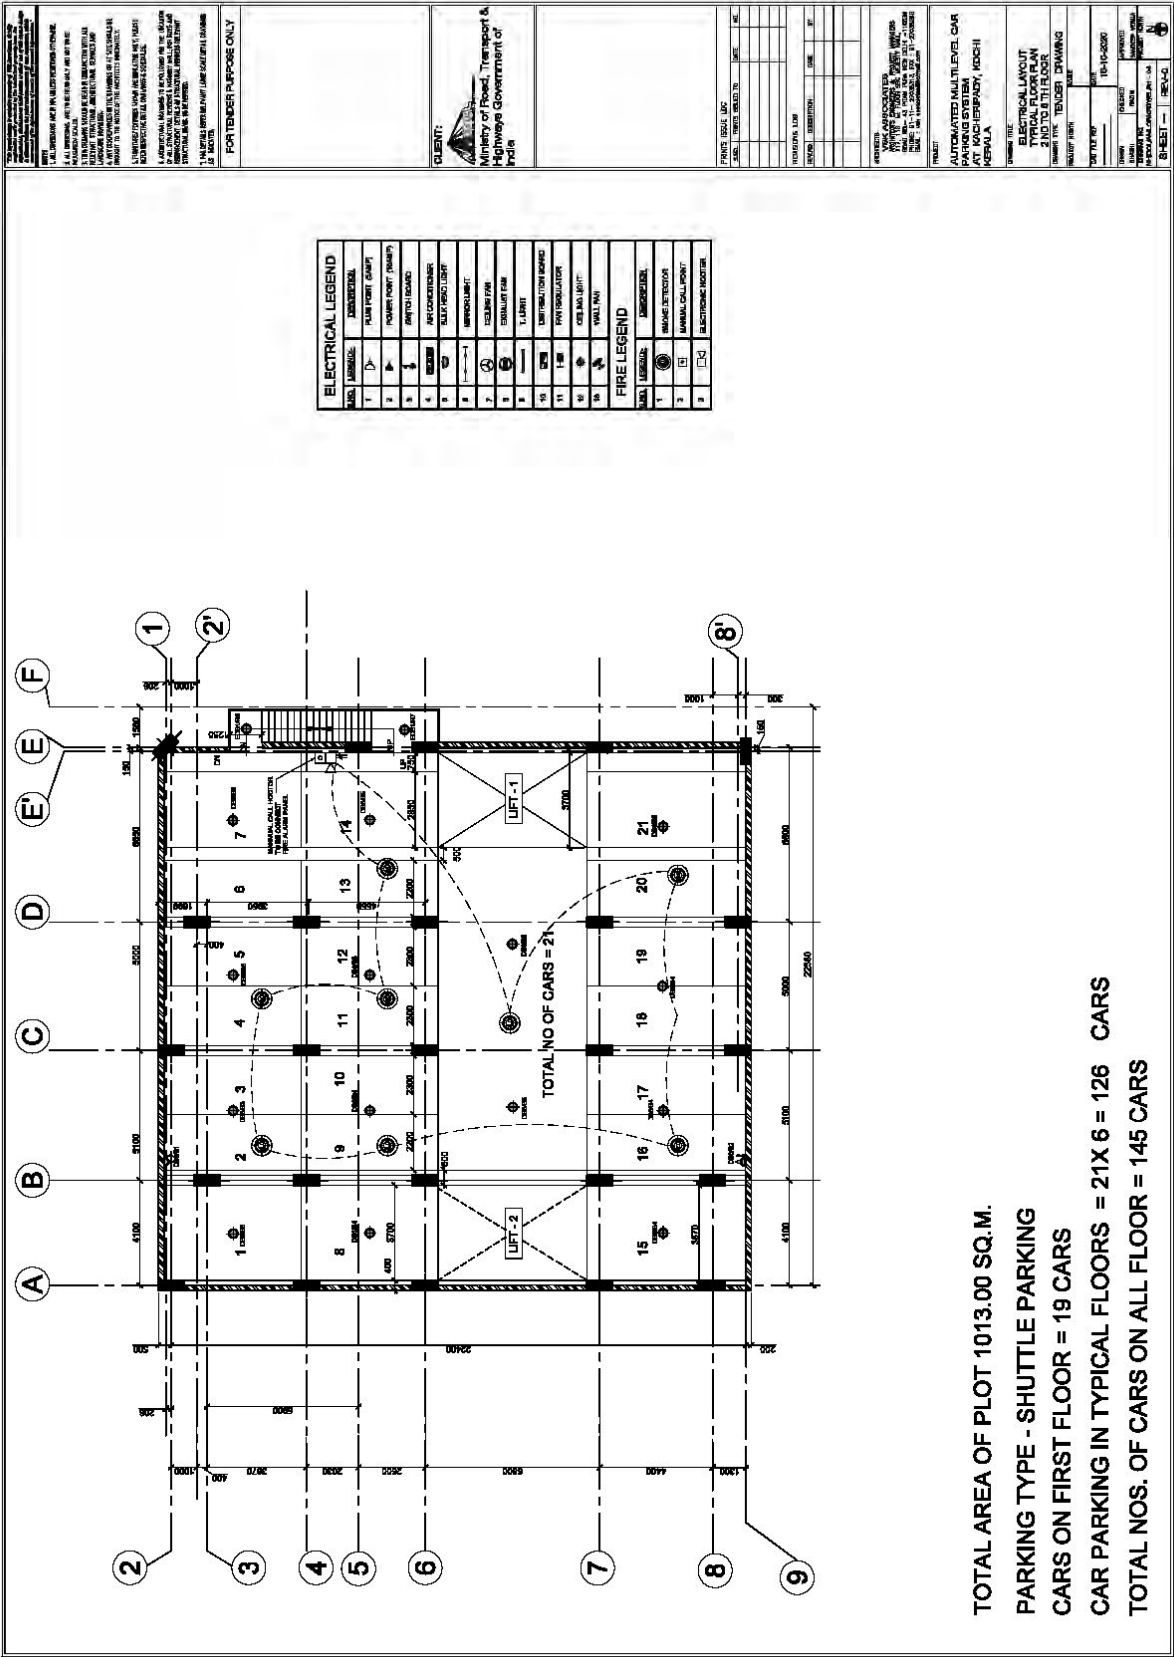


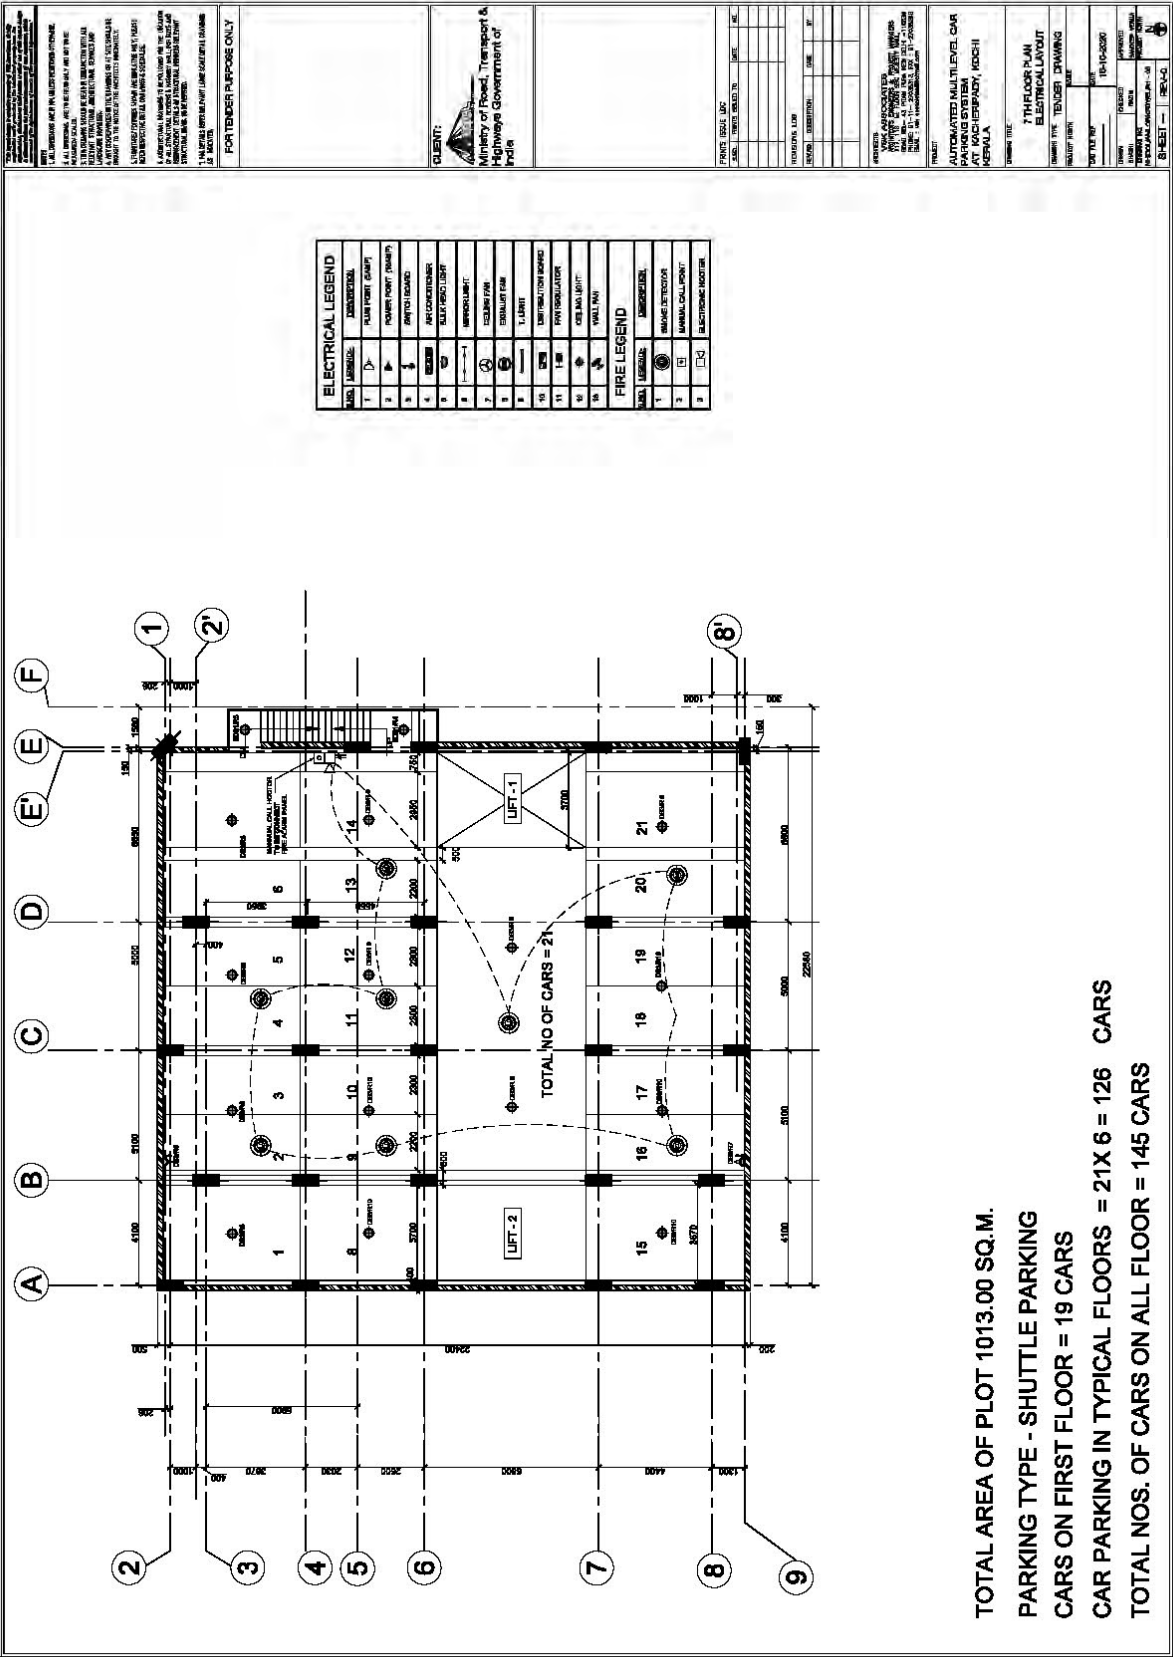

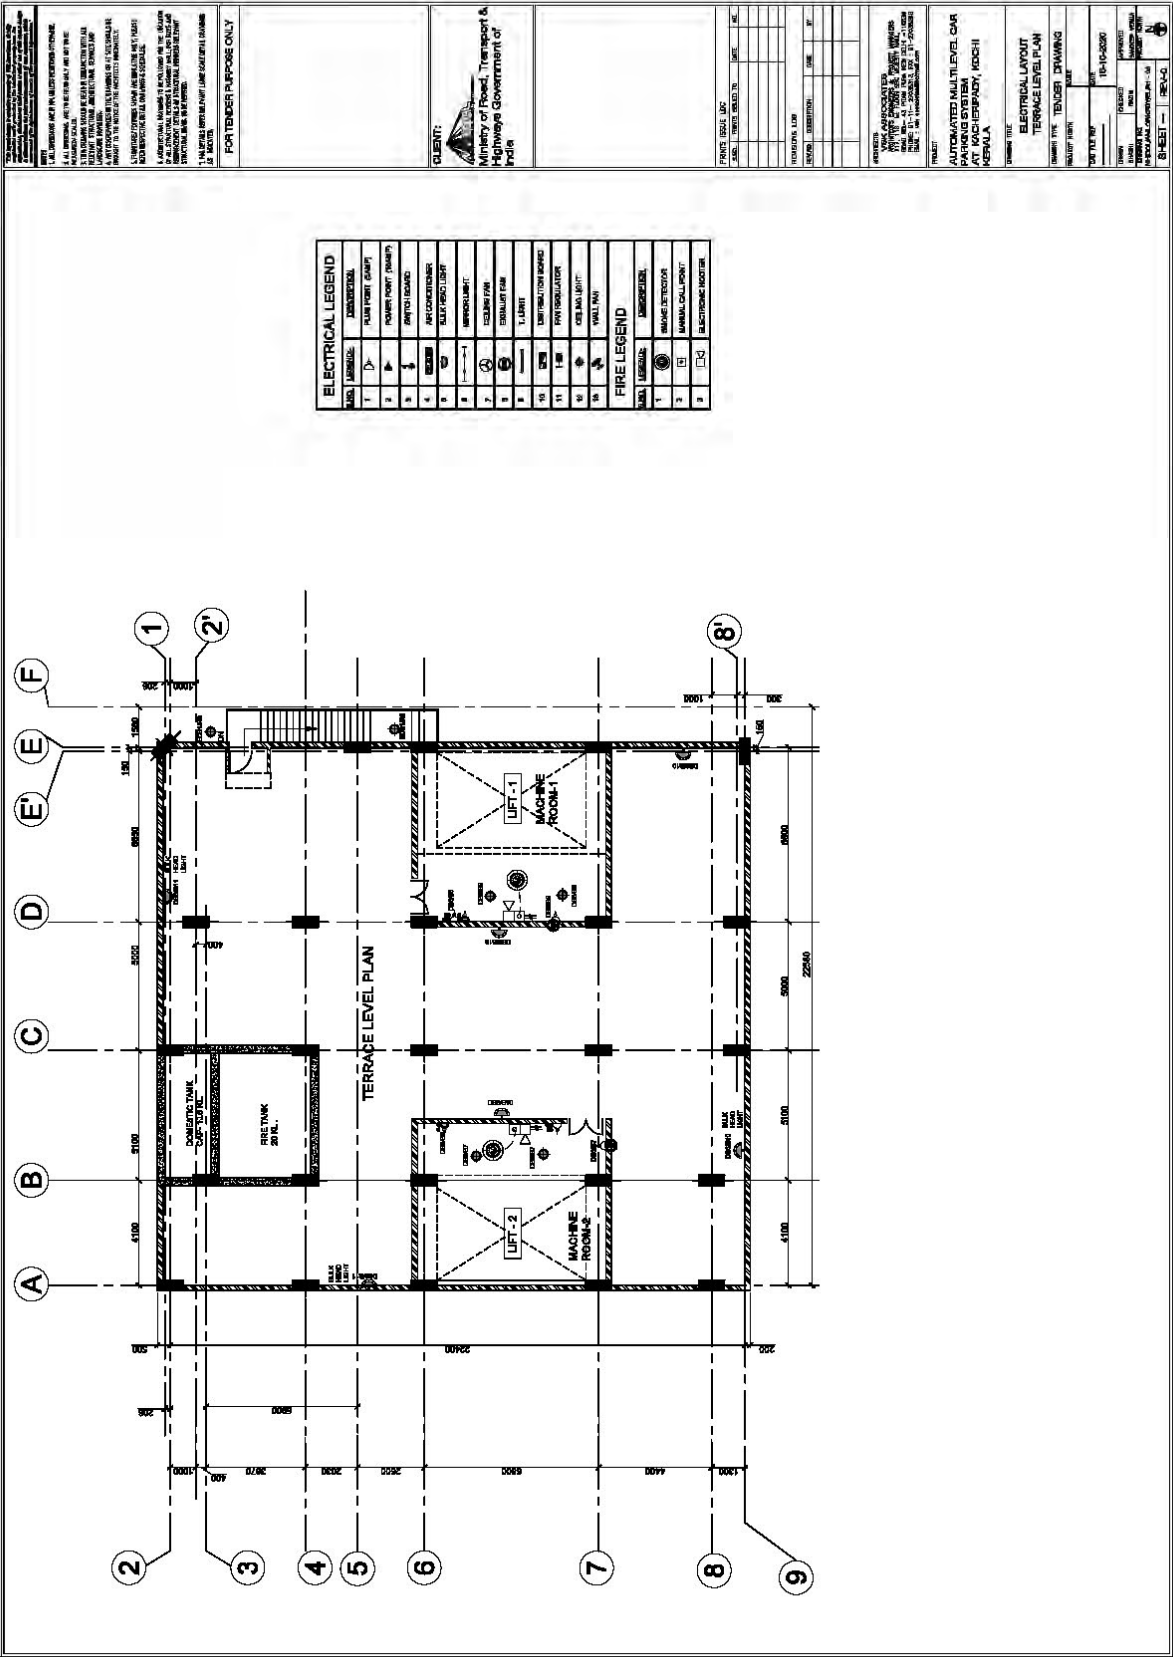


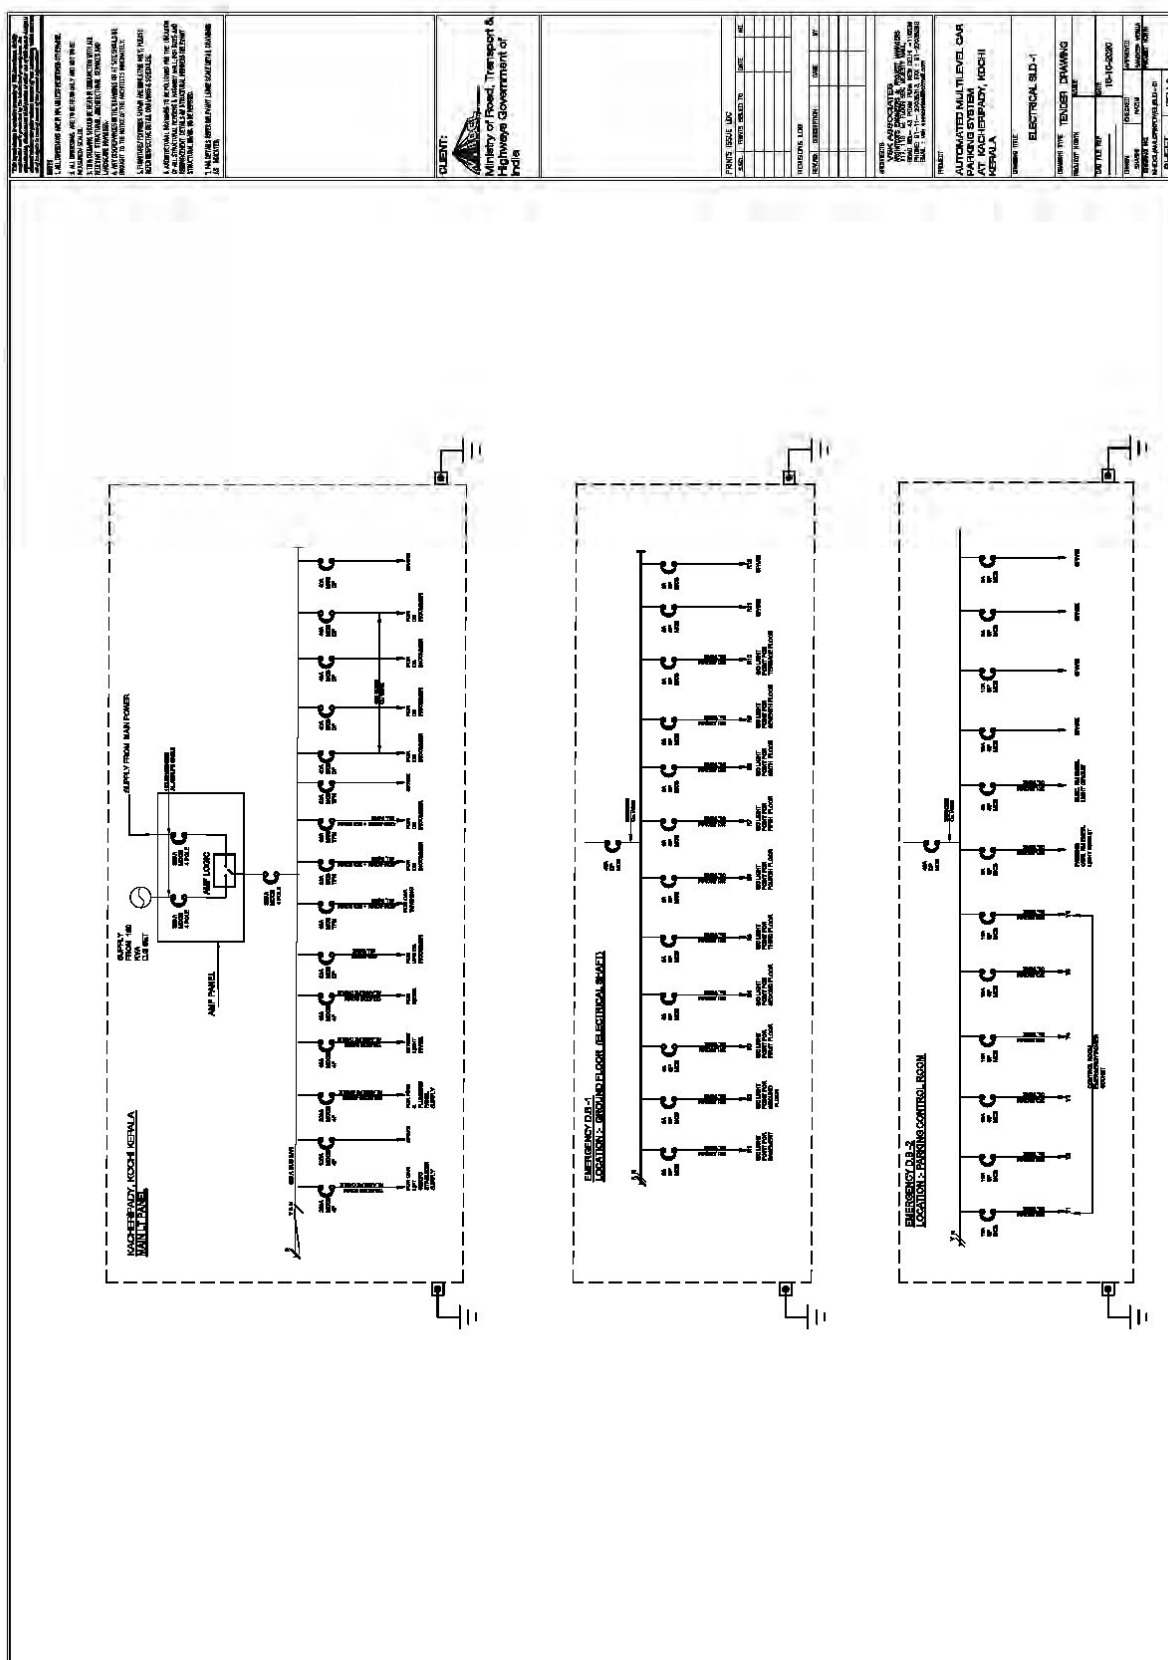


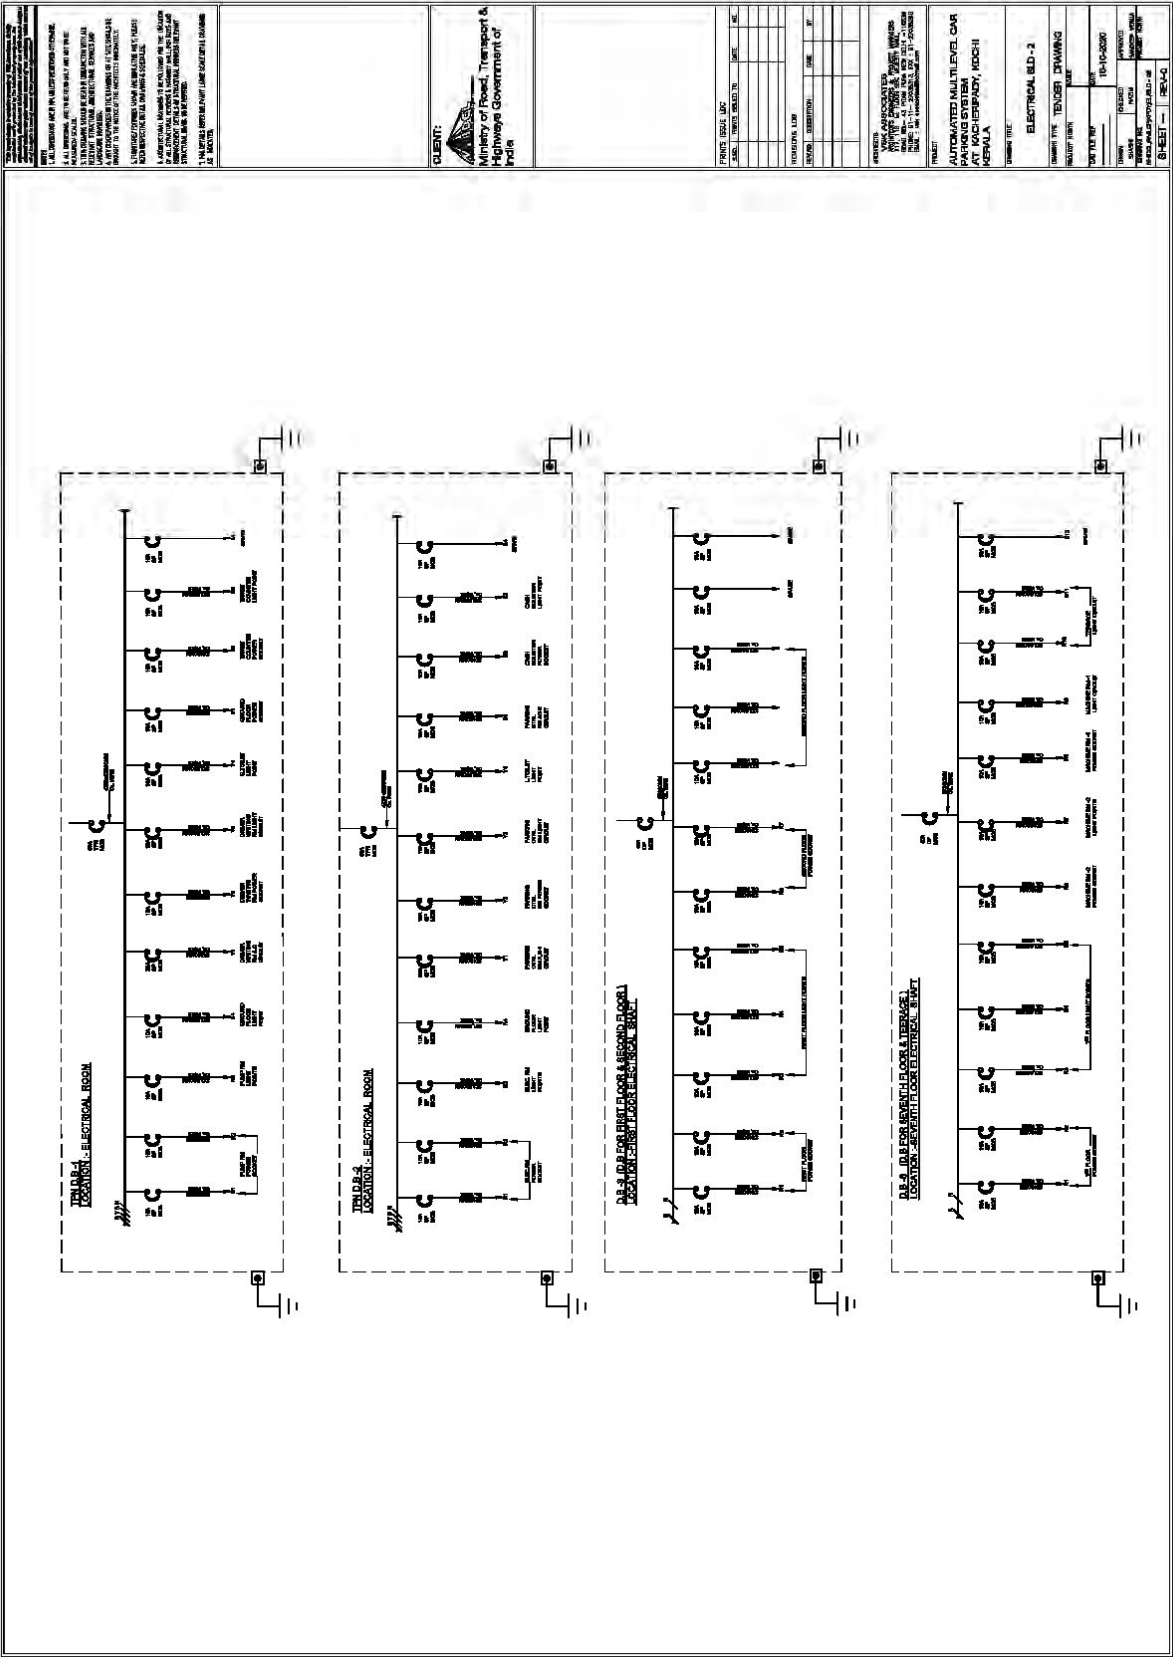


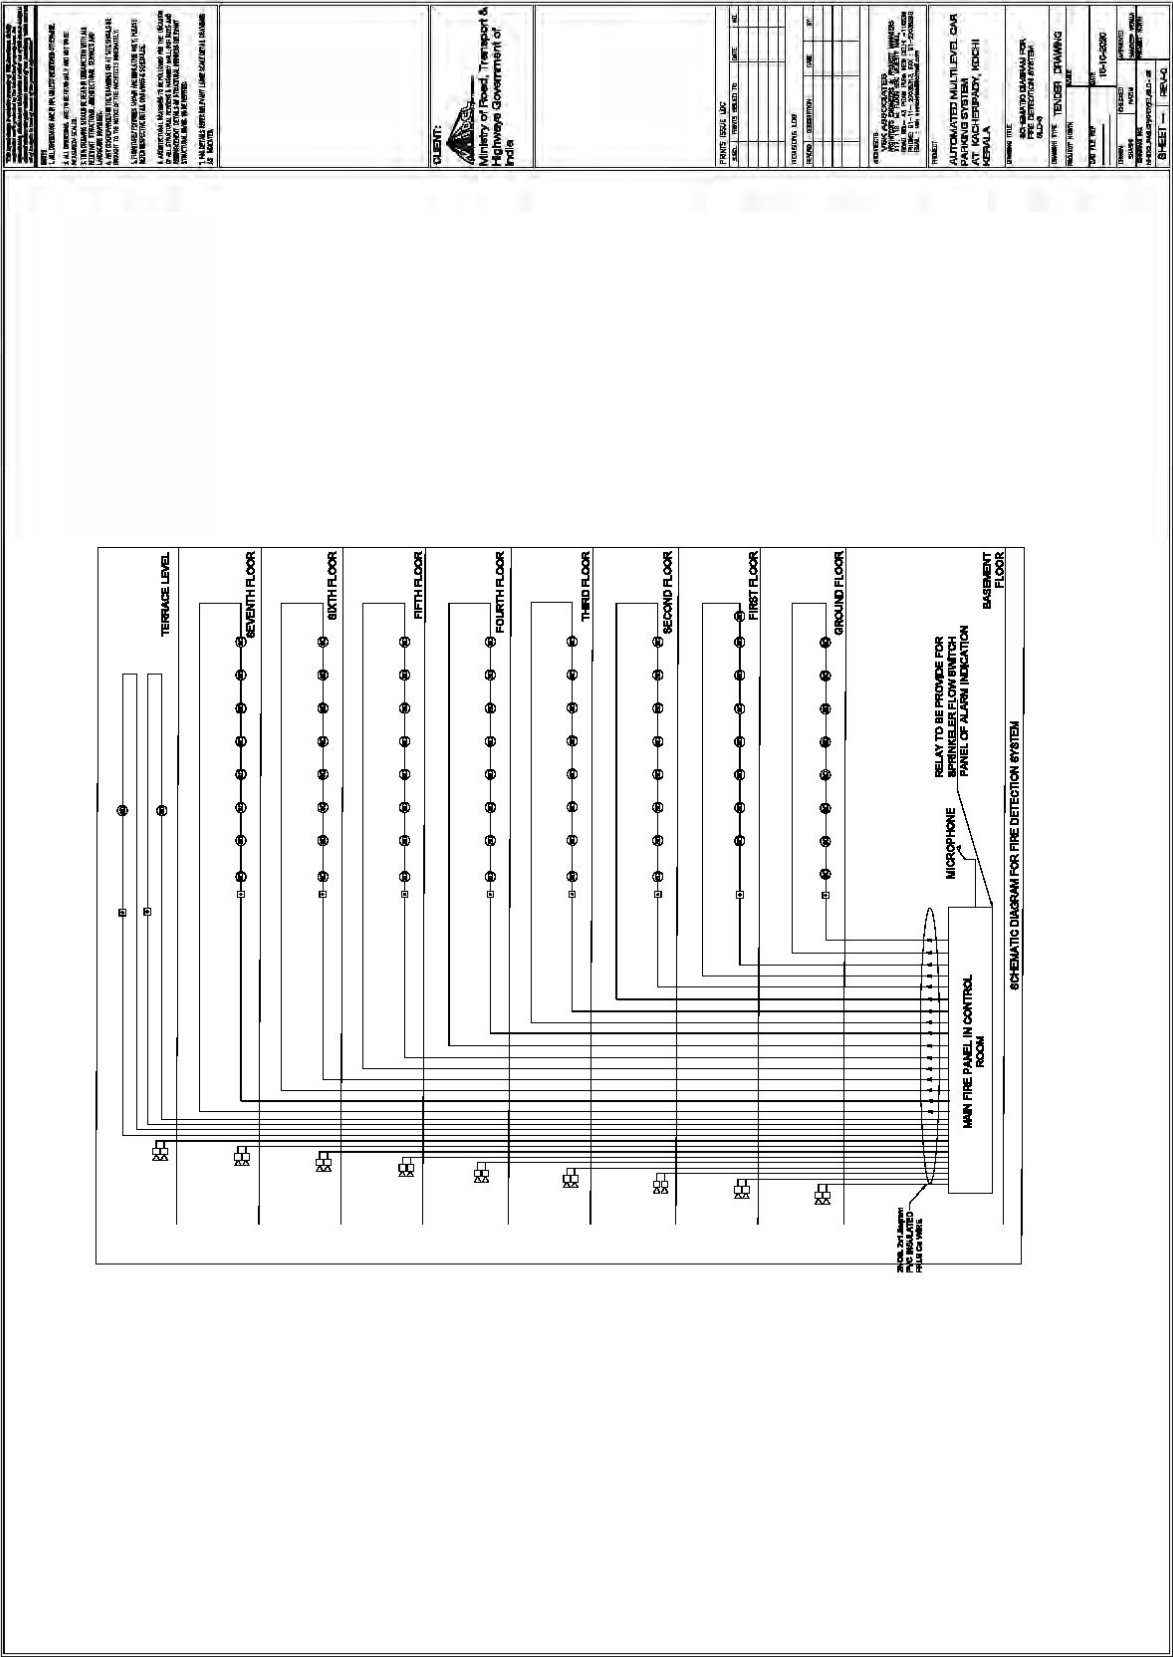



<u>PROPOSED AUTOMATED MULTI LEVEL CAR PARKING AT KACHERIPADY KOCHIN KERALA</u>			
<u>FIRE FIGHTING LAYOUT DRAWINGS (FLOOR PLANS)</u>			
<u>S.NO.</u>	<u>DRAWING TITLE</u>	<u>DRAWING NO.</u>	<u>REMARK</u>
1	UNDER GROUND FIRE TANK LIFT PIT LAYOUT PLAN	NHIDCL/AMLCP/KPDY/FF/A1-01	LIFT PIT,PUMP ROOM
2	FIRE FIGHTING LAYOUT GROUND FLOOR PLAN	NHIDCL/AMLCP/KPDY/FF/A1-02	ENTRY AND EXIT
3	FIRE FIGHTING FIRST FLOOR PLAN	NHIDCL/AMLCP/KPDY/EL/A1-03	FIRST FLOOR
4	FIRE FIGHTING 2 ND FLOOR TO 7 TH TYPICAL FLOOR	NHIDCL/AMLCP/KPDY/EL/A1-04	TYPICAL FLOORS
5	FIRE FIGHTING TERRACE PLAN	NHIDCL/AMLCP/KPDY/EL/A1-05	TERRACE
6	FIRE FIGHTING LAYOUT SLD	NHIDCL/AMLCP/KPDY/FF/SLD - 01	SLD-1

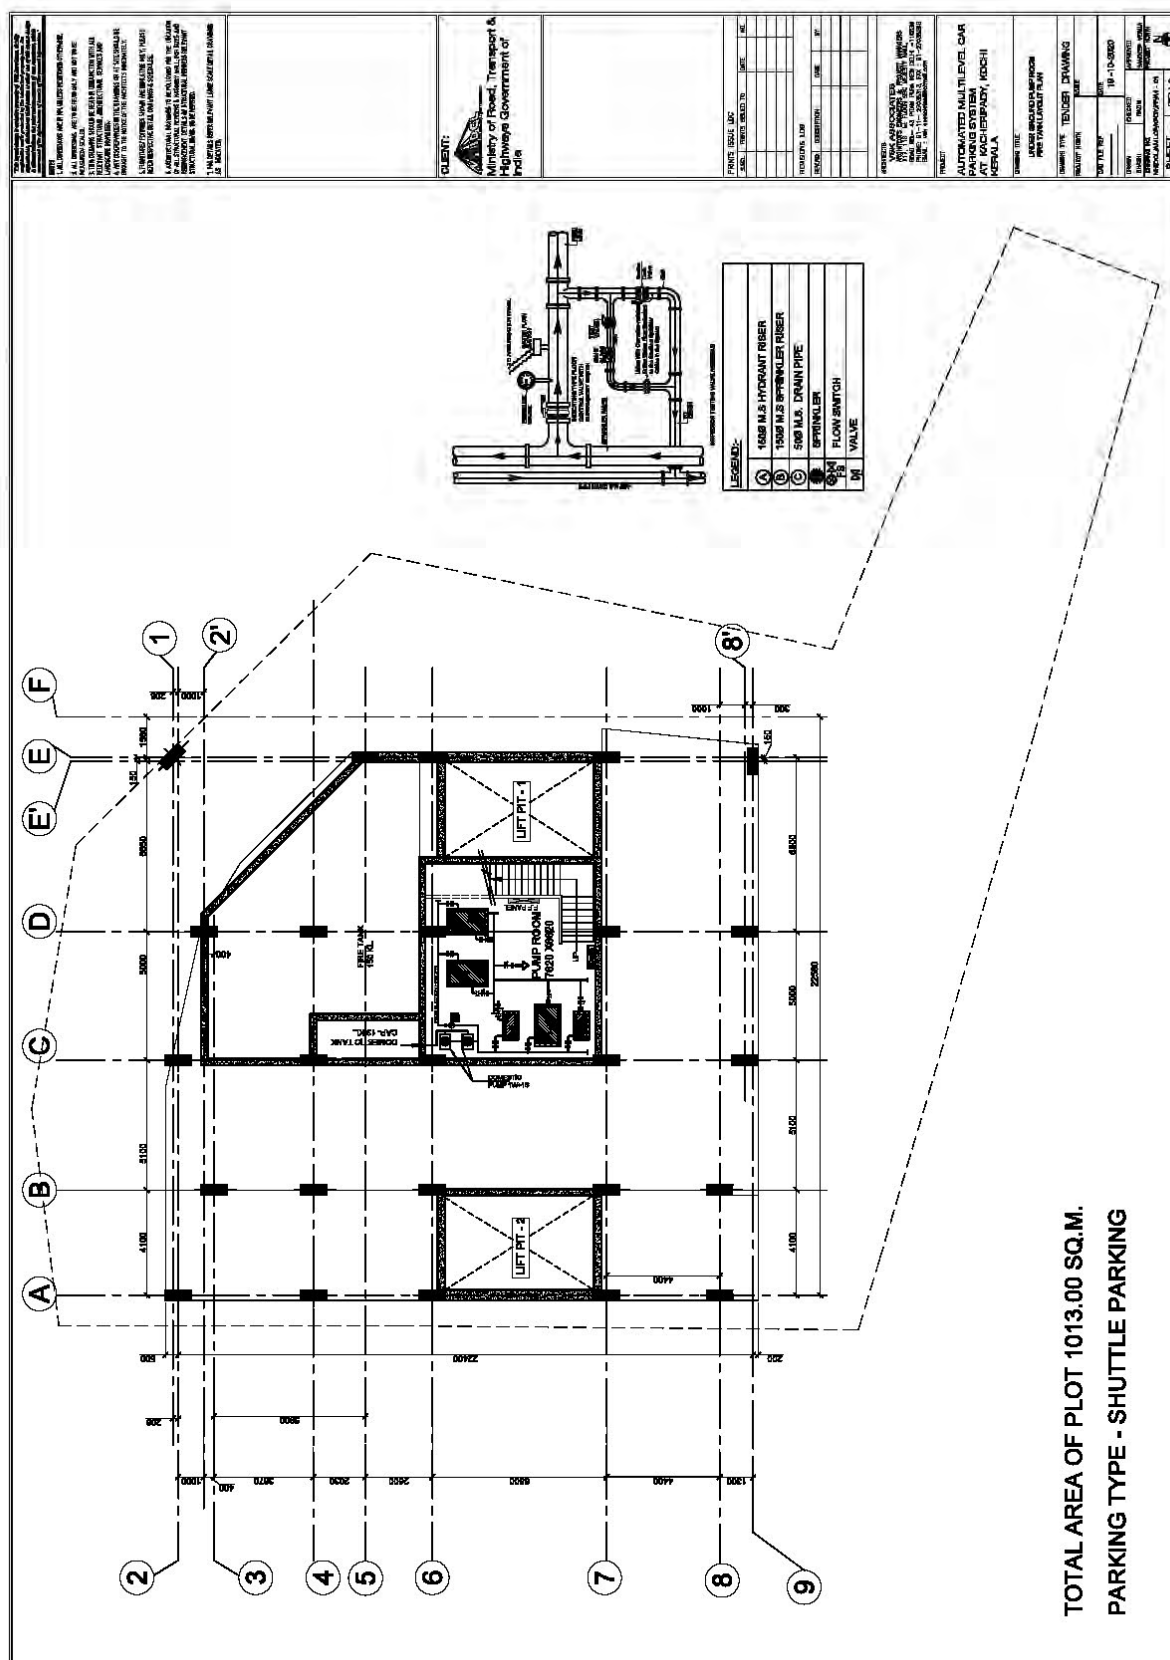


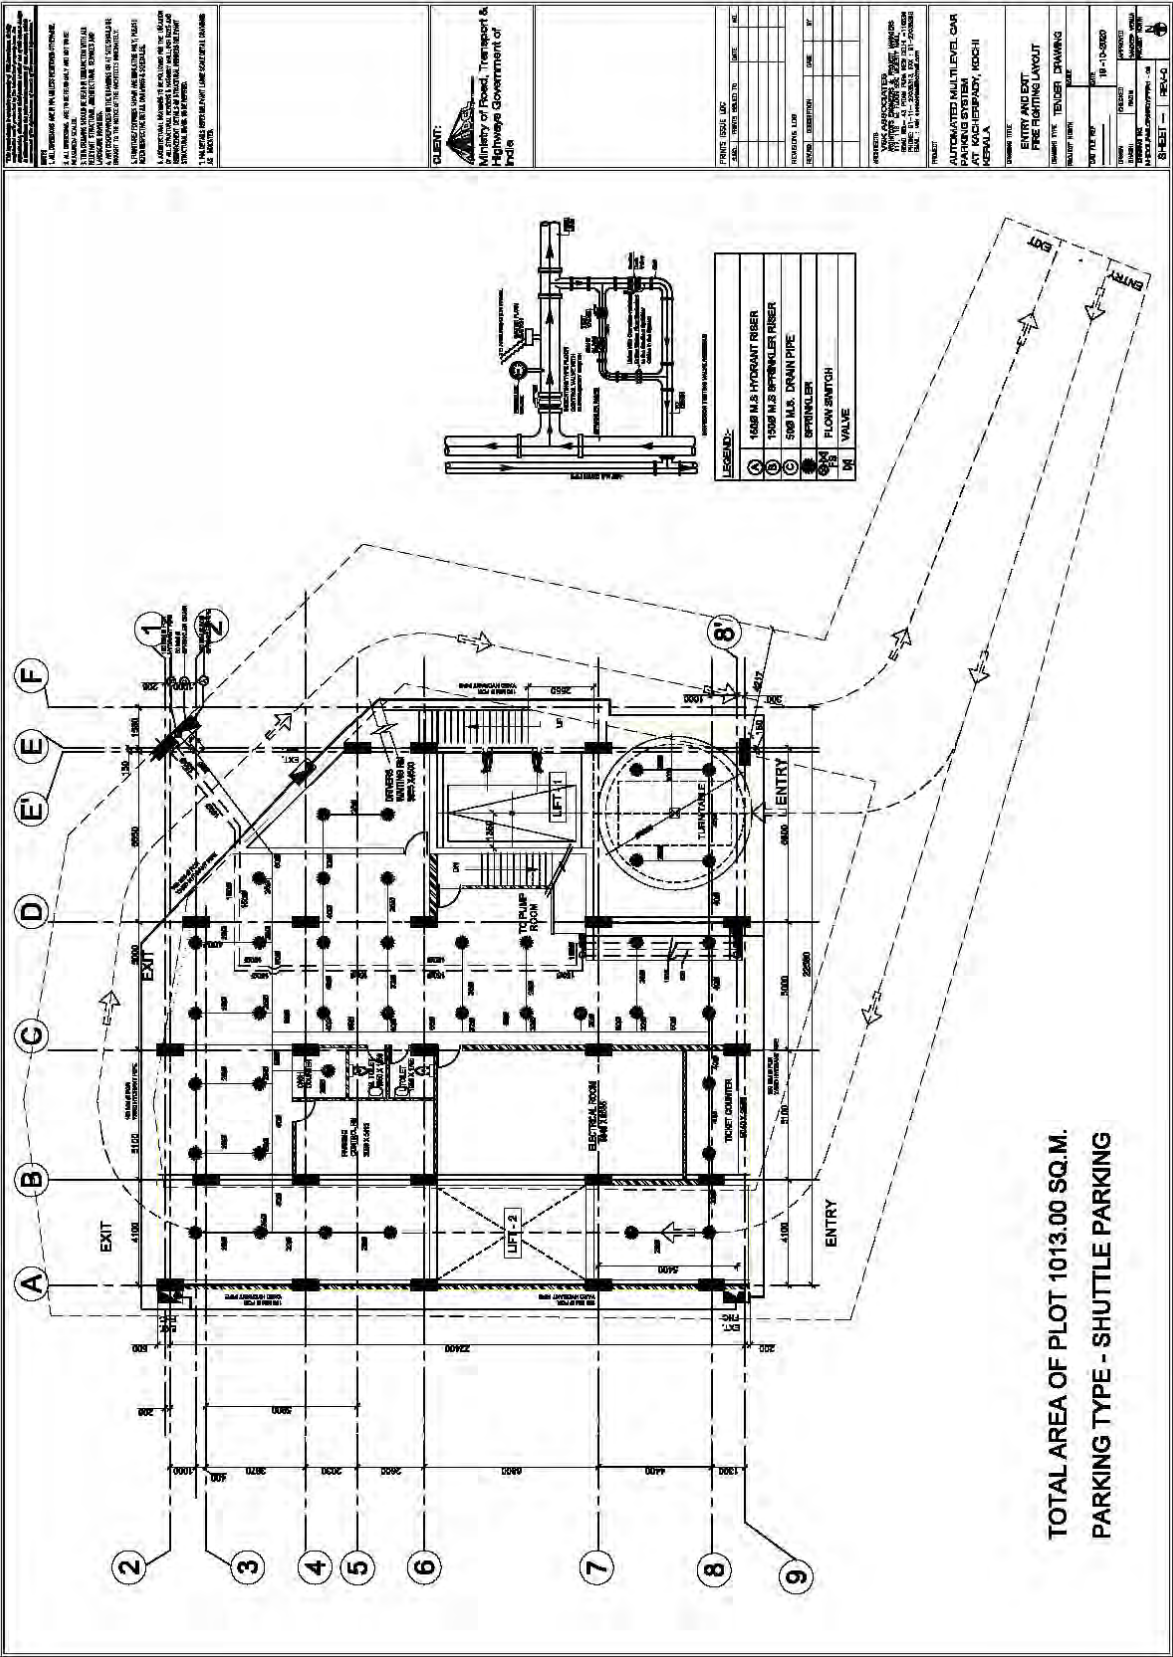

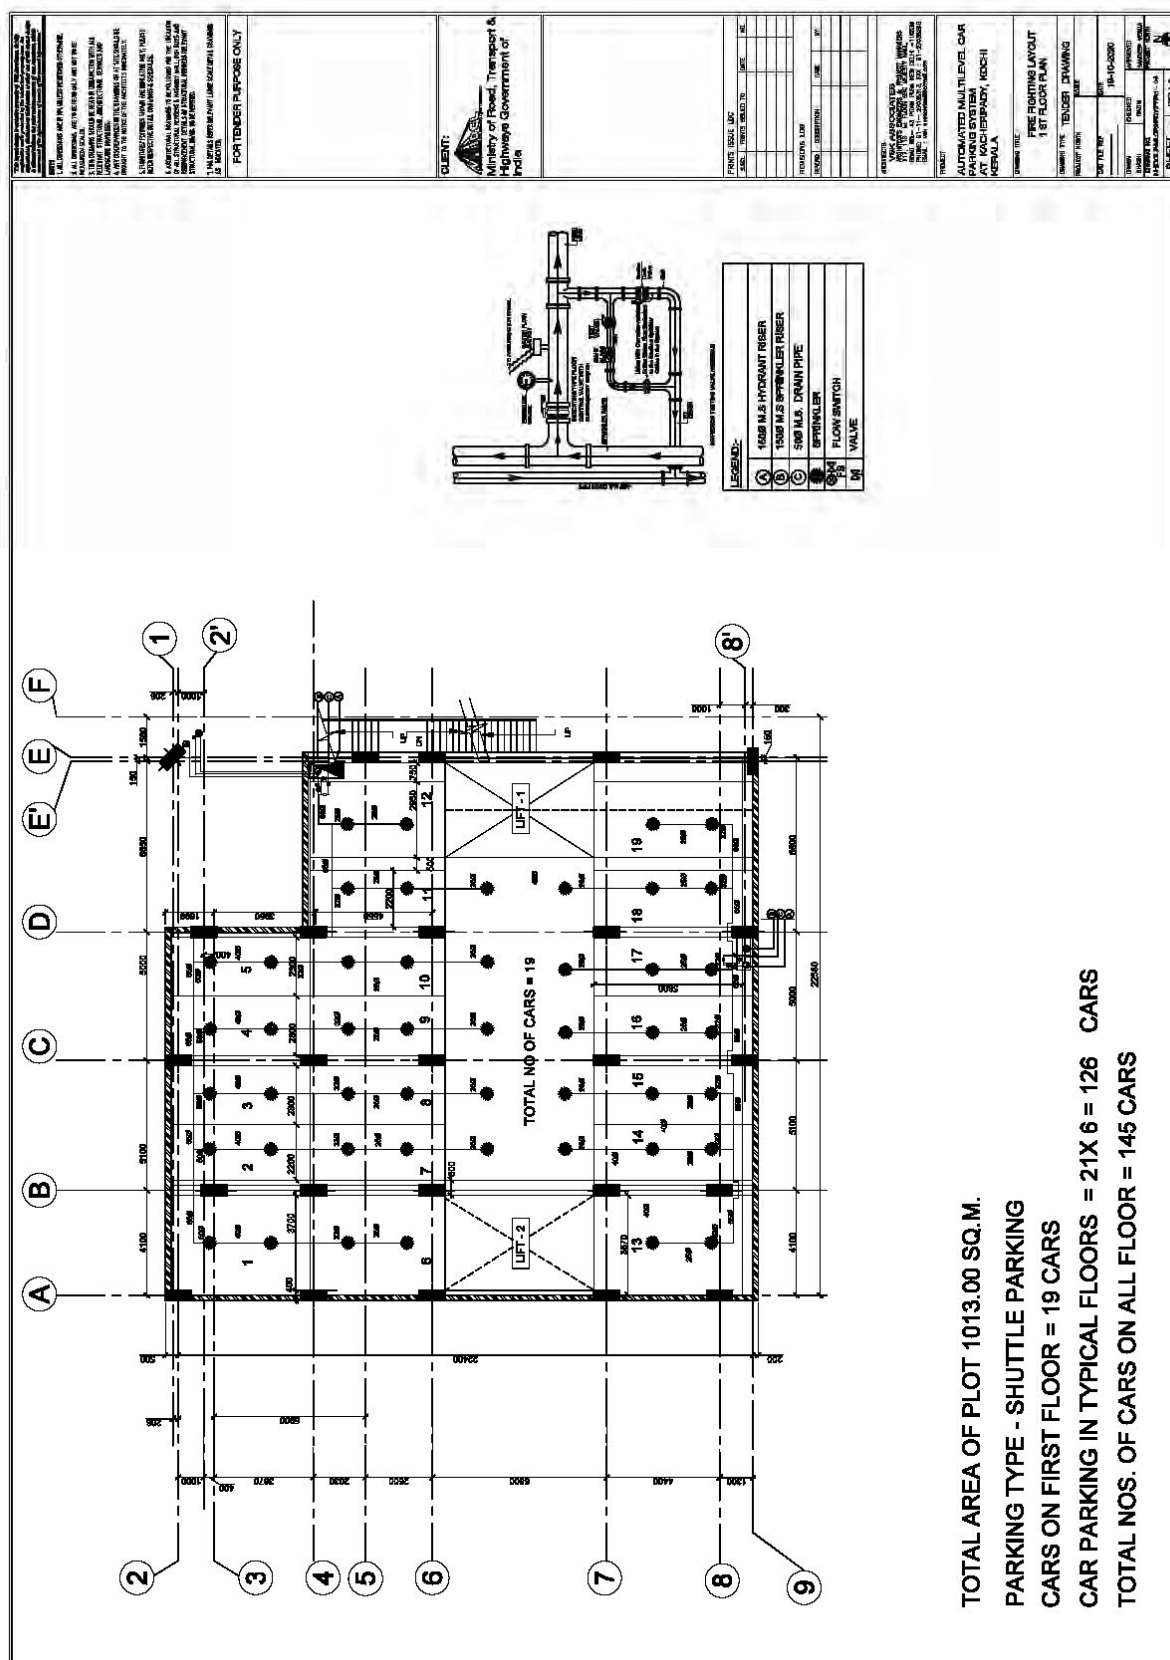

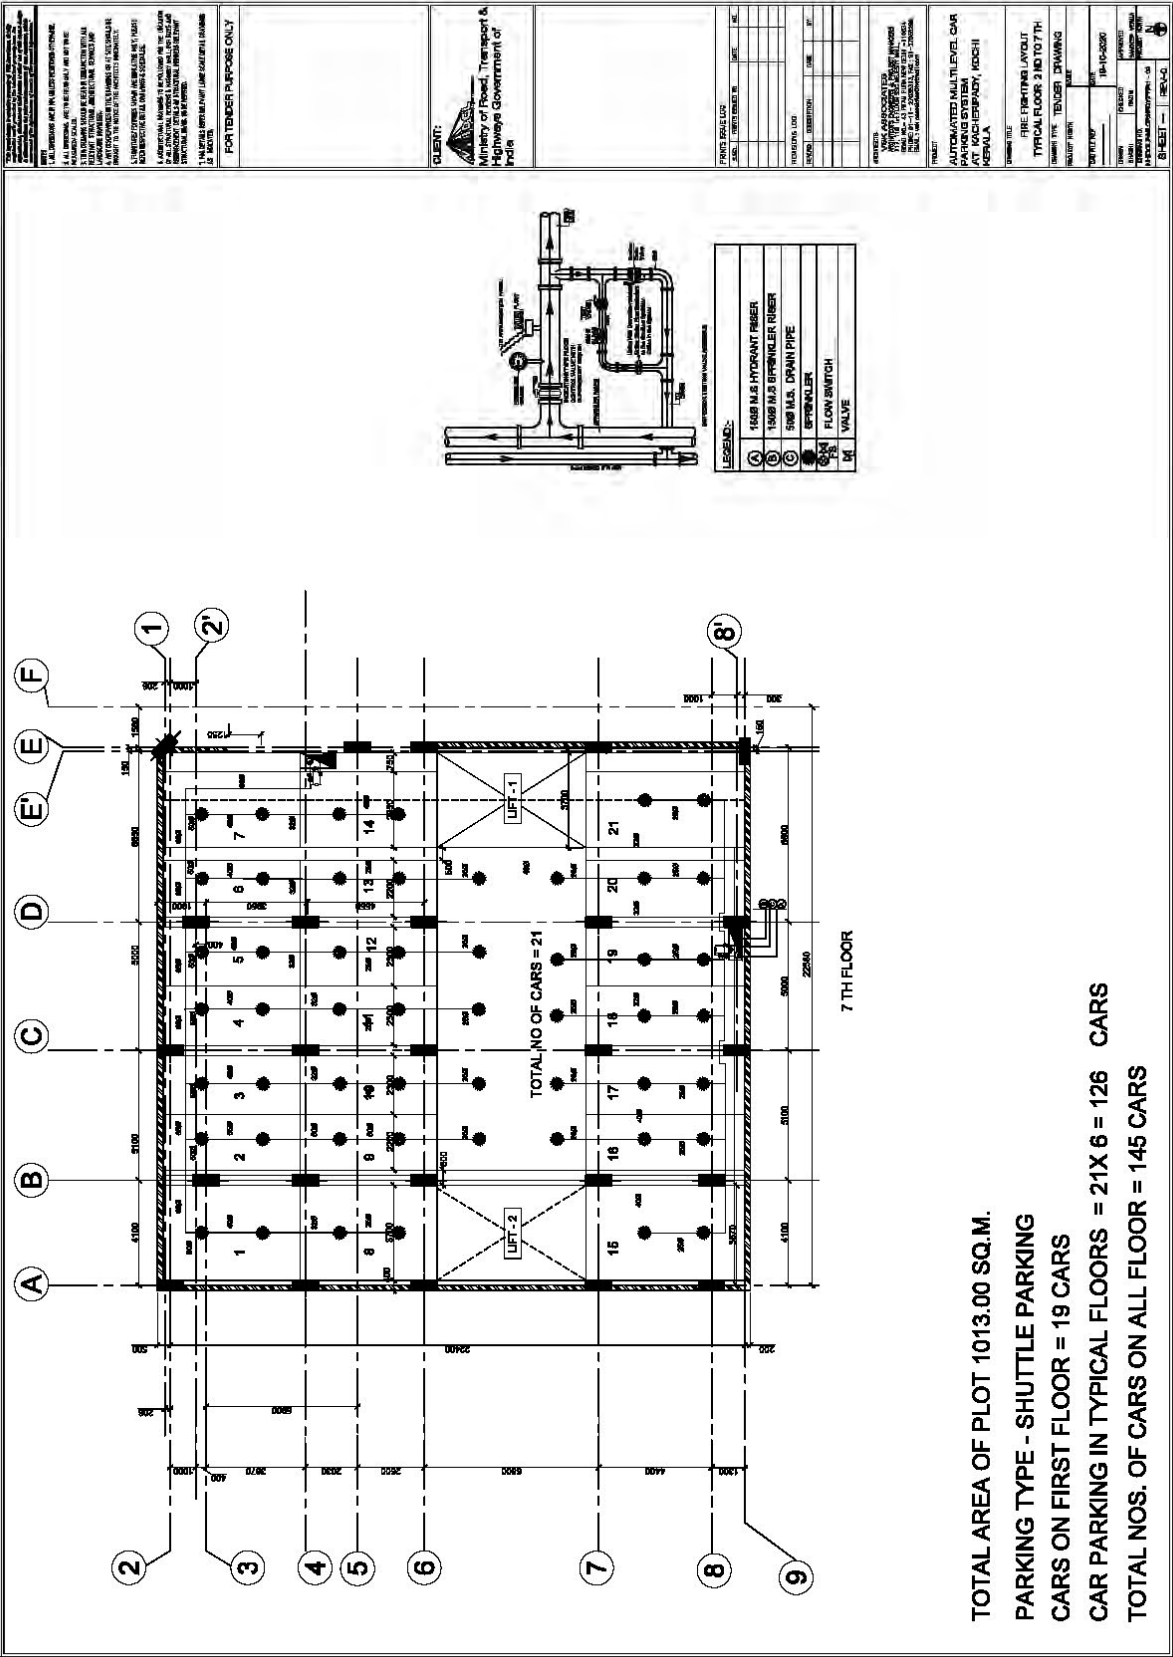

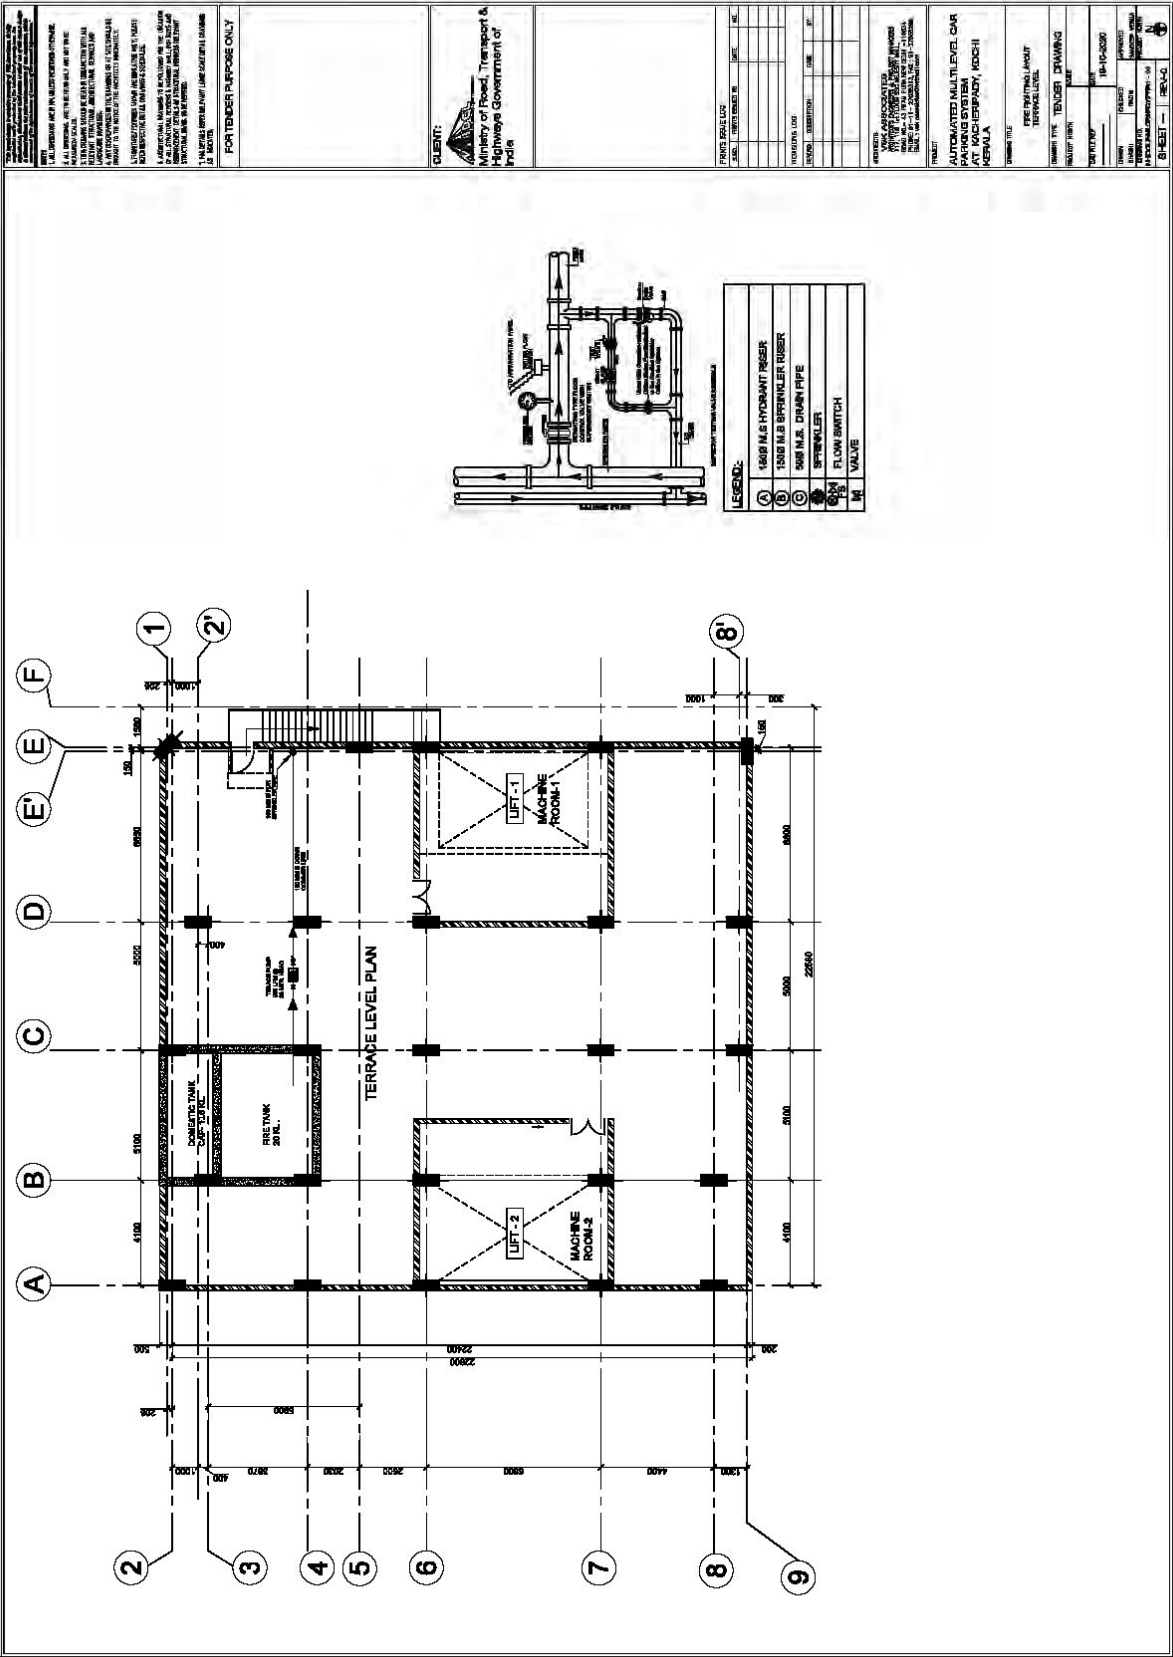 



<u>PROPOSED AUTOMATED MULTI LEVEL CAR PARKING AT KACHERIPADY KOCHIN KERALA</u>			
<u>PLUMBING LAYOUT DRAWINGS (FLOOR PLANS)</u>			
<u>S.NO.</u>	<u>DRAWING TITLE</u>	<u>DRAWING NO.</u>	<u>REMARK</u>
1	UNDER GROUND FIRE TANK LIFT PIT LAYOUT PLAN PLUMBING LAYOUT	NHIDCL/AMLCP/KPDY/PLB/A1-01	LIFT PIT,PUMP ROOM
2	PLUMBING LAYOUT GROUND FLOOR PLAN	NHIDCL/AMLCP/KPDY/PLB/A1-02	ENTRY AND EXIT
3	PLUMBING LAYOUT WATER SUPPLY GROUND FLOOR PLAN	NHIDCL/AMLCP/KPDY/PLB/A1-03	ENTRY AND EXIT
4	PLUMBING LAYOUT FIRST FLOOR	NHIDCL/AMLCP/KPDY/PLB/A1-04	FIRST FLOOR
5	PLUMBING LAYOUT 2 ND FLOOR TO 6 TH FLOOR	NHIDCL/AMLCP/KPDY/PLB/A1-05	TYPICAL FLOORS
6	PLUMBING LAYOUT TERRACE	NHIDCL/AMLCP/KPDY/PLB/A1-06	TERRACE
7	PLUMBING LAYOUT SLD	NHIDCL/AMLCP/KPDY/PLB/A3-01	SLD-1

