


**Additional Appendix C**  
**Drawings Set**

<b><u>PROPOSED AUTOMATED MULTI LEVEL CAR PARKING AT ERNAKULAM SOUTH METRO STATION</u></b> <b><u>KOCHIN KERALA</u></b>			
<b><u>LIST OF DRAWINGS</u></b>			
<b><u>SURVEY PLAN</u></b>			
<b><u>S.NO.</u></b>	<b><u>DRAWING TITLE</u></b>	<b><u>DRAWING NO.</u></b>	<b><u>REMARK</u></b>
1	SURVEY PLAN	NHIDCL/AMLCP/ENKLM/A/SL-01	SURVEY PLAN
2	SITE PLAN	NHIDCL/AMLCP/ENKLM/A/L-01	SITE PLAN
<b><u>ARCHITECTURAL DRAWINGS (FLOOR PLANS)</u></b>			
1	LIFT PIT, PUMP ROOM AND WATER TANK LEVEL PLAN	NHIDCL/AMLCP/ENKLM/A/A1 - 01	LIFT PIT, PUMP ROOM AND WATER TANK LEVEL PLAN
2	GROUND FLOOR PLAN	NHIDCL/AMLCP/ENKLM/A/A1 - 02	ENTRY AND EXIT LEVEL
3	TYPICAL PARKING FLOOR WITH COORIDOR	NHIDCL/AMLCP/ENKLM/A/A1-03	TYPICAL PARKING
4	TYPICAL PARKING FLOORS WITHOUT CORRIDOR	NHIDCL/AMLCP/ENKLM/A/A1-04	TYPICAL PARKING
5	TERRACE LEVEL PLAN	NHIDCL/AMLCP/ENKLM/A/A1 - 05	TERRACE
6	MUMTY LEVEL PLAN	NHIDCL/AMLCP/ENKLM/A/A1 - 06	WATER TANK LEVEL
7	SECTION AT - A,A AND B,B	NHIDCL/AMLCP/ENKLM/A/A3 -01	
8	ELEVATION - 1 AND 2	NHIDCL/AMLCP/ENKLM/A/A2 -01	
9	ELEVATION - 3 AND 4	NHIDCL/AMLCP/ENKLM/A/A2 -02	


SECTION IV BIDDING FORMS: Schedules

ADDITIONAL APPENDIX C (DRAWINGS)

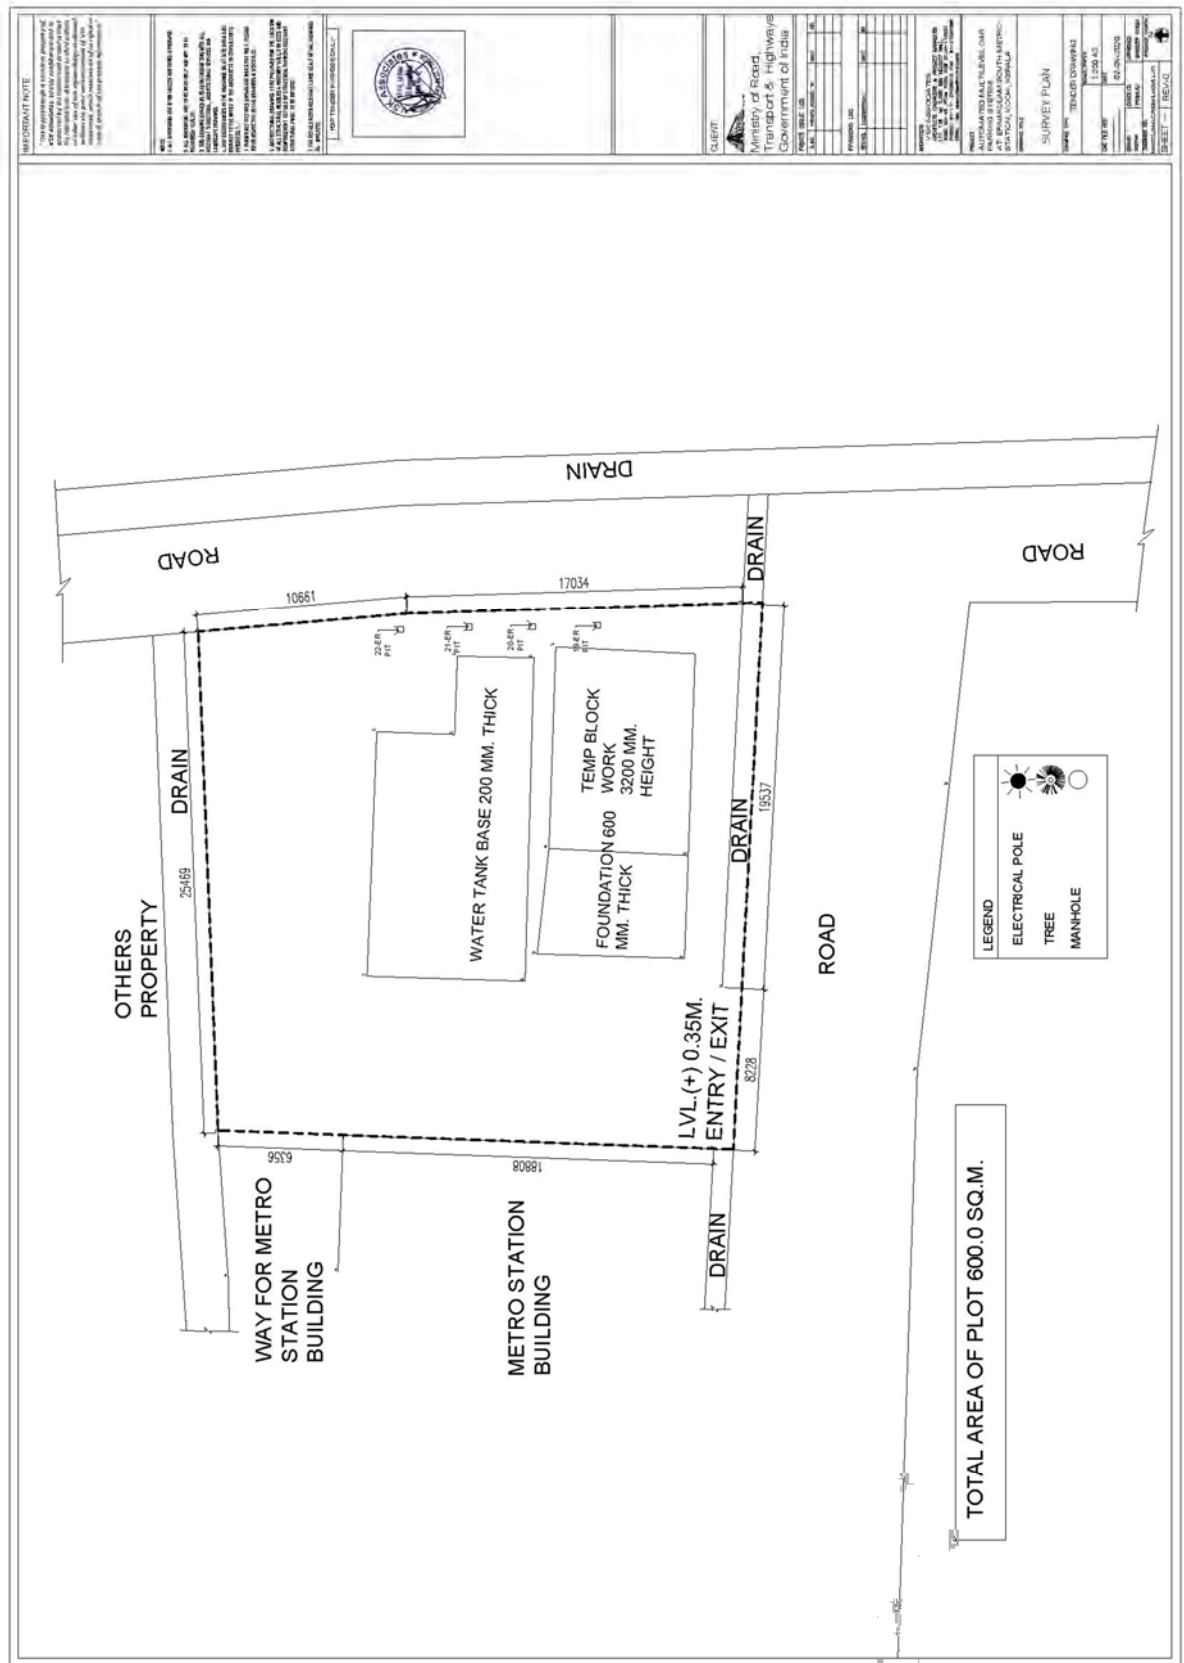


SECTION IV BIDDING FORMS: Schedules

ADDITIONAL APPENDIX C (DRAWINGS)

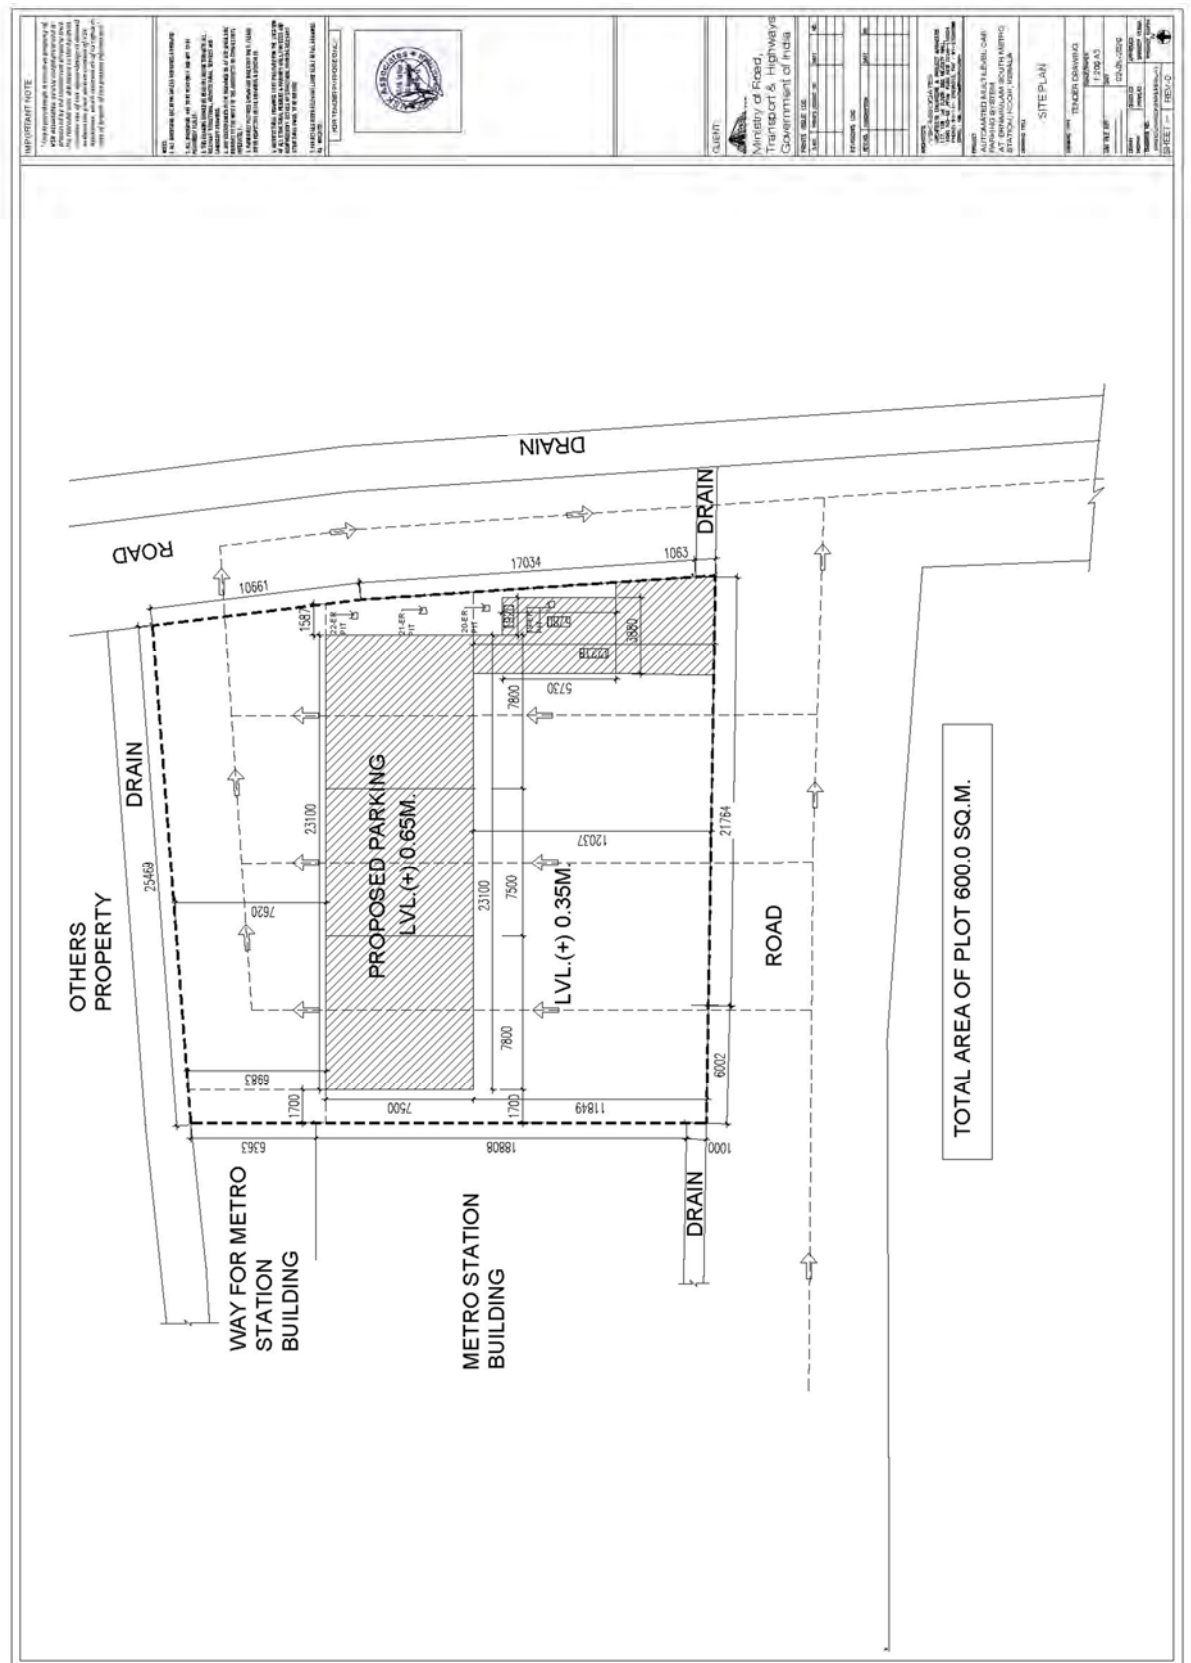





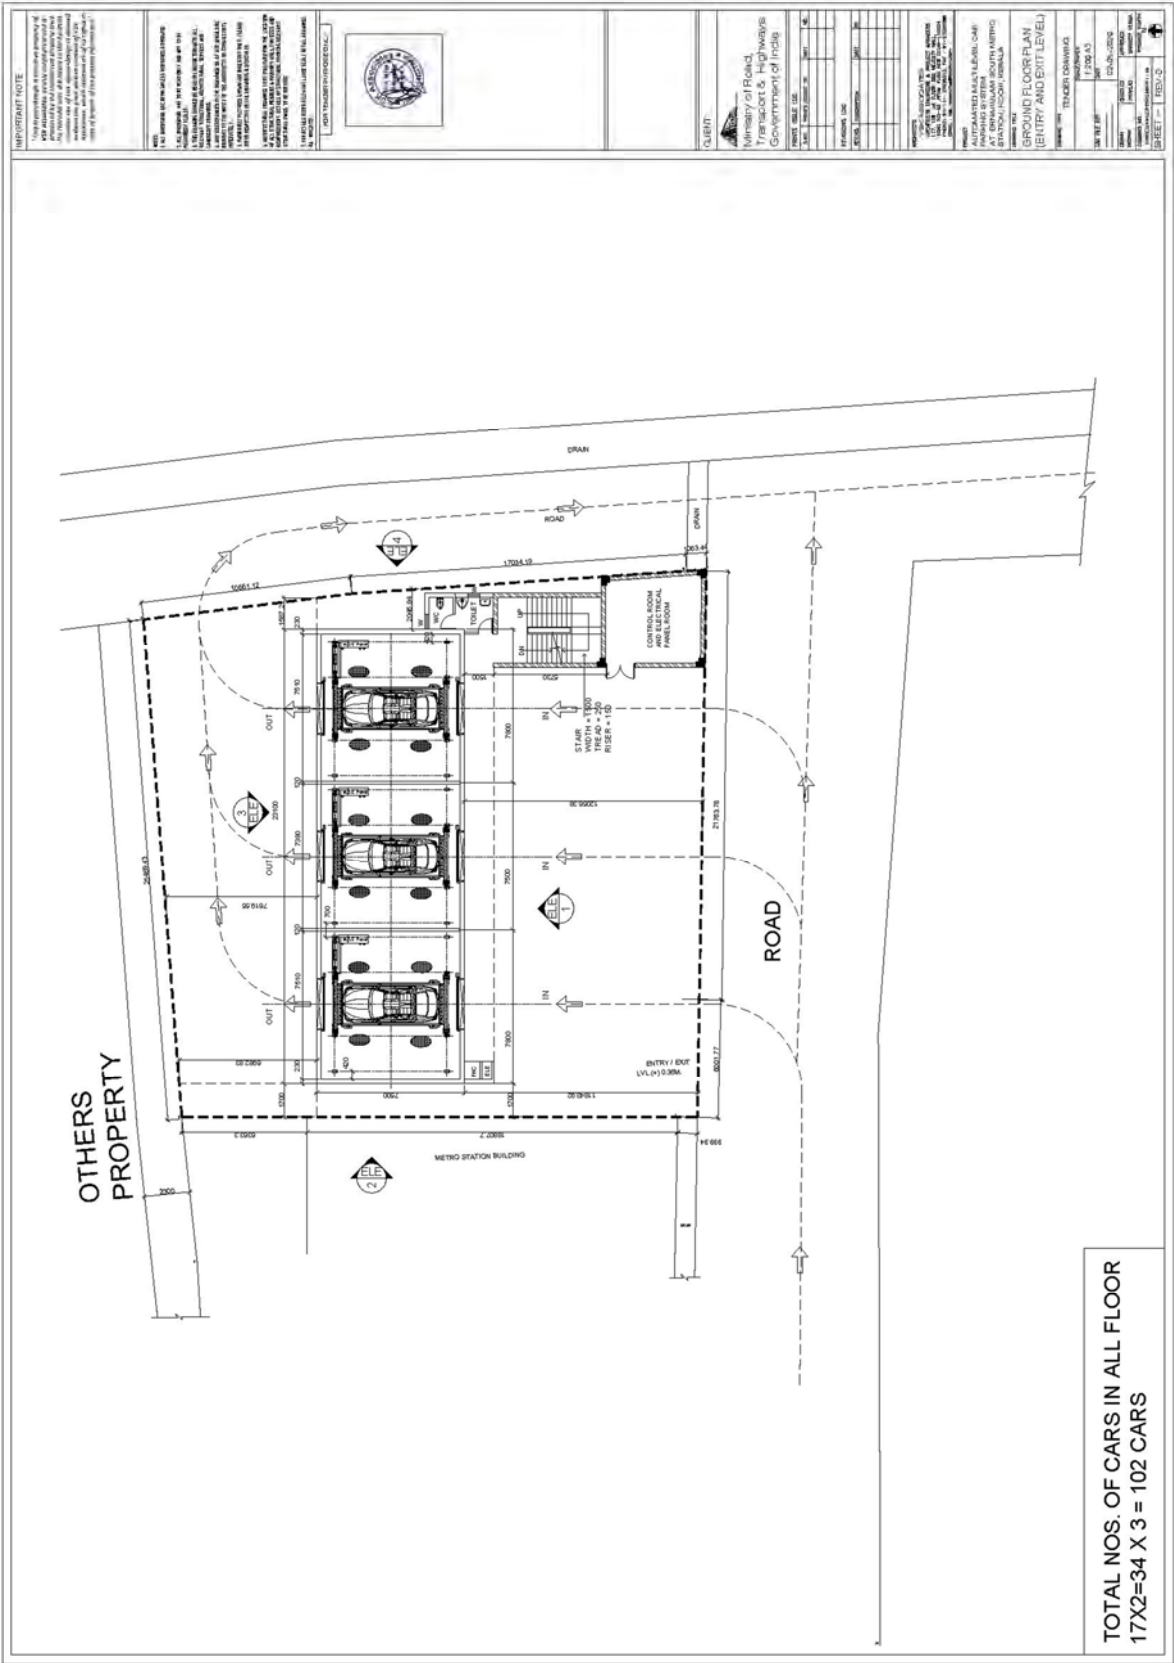

SECTION IV BIDDING FORMS: Schedules


ADDITIONAL APPENDIX C (DRAWINGS)

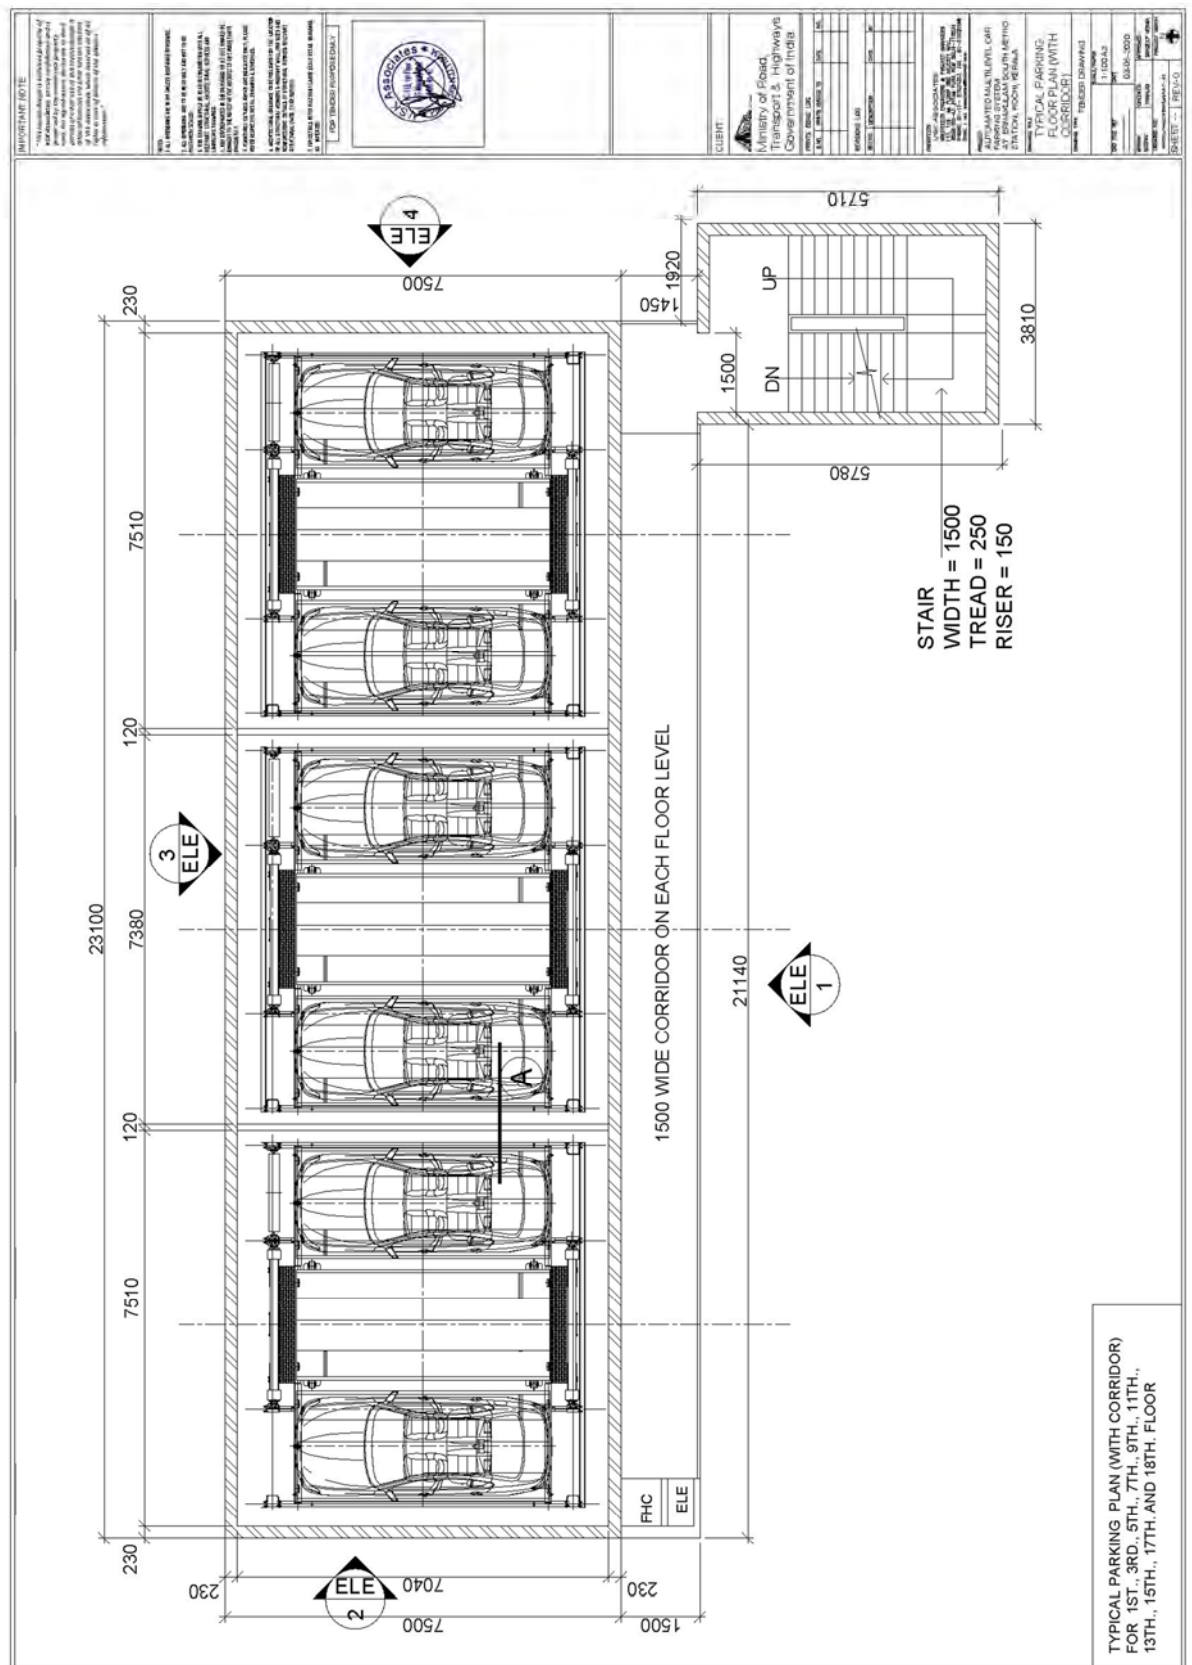

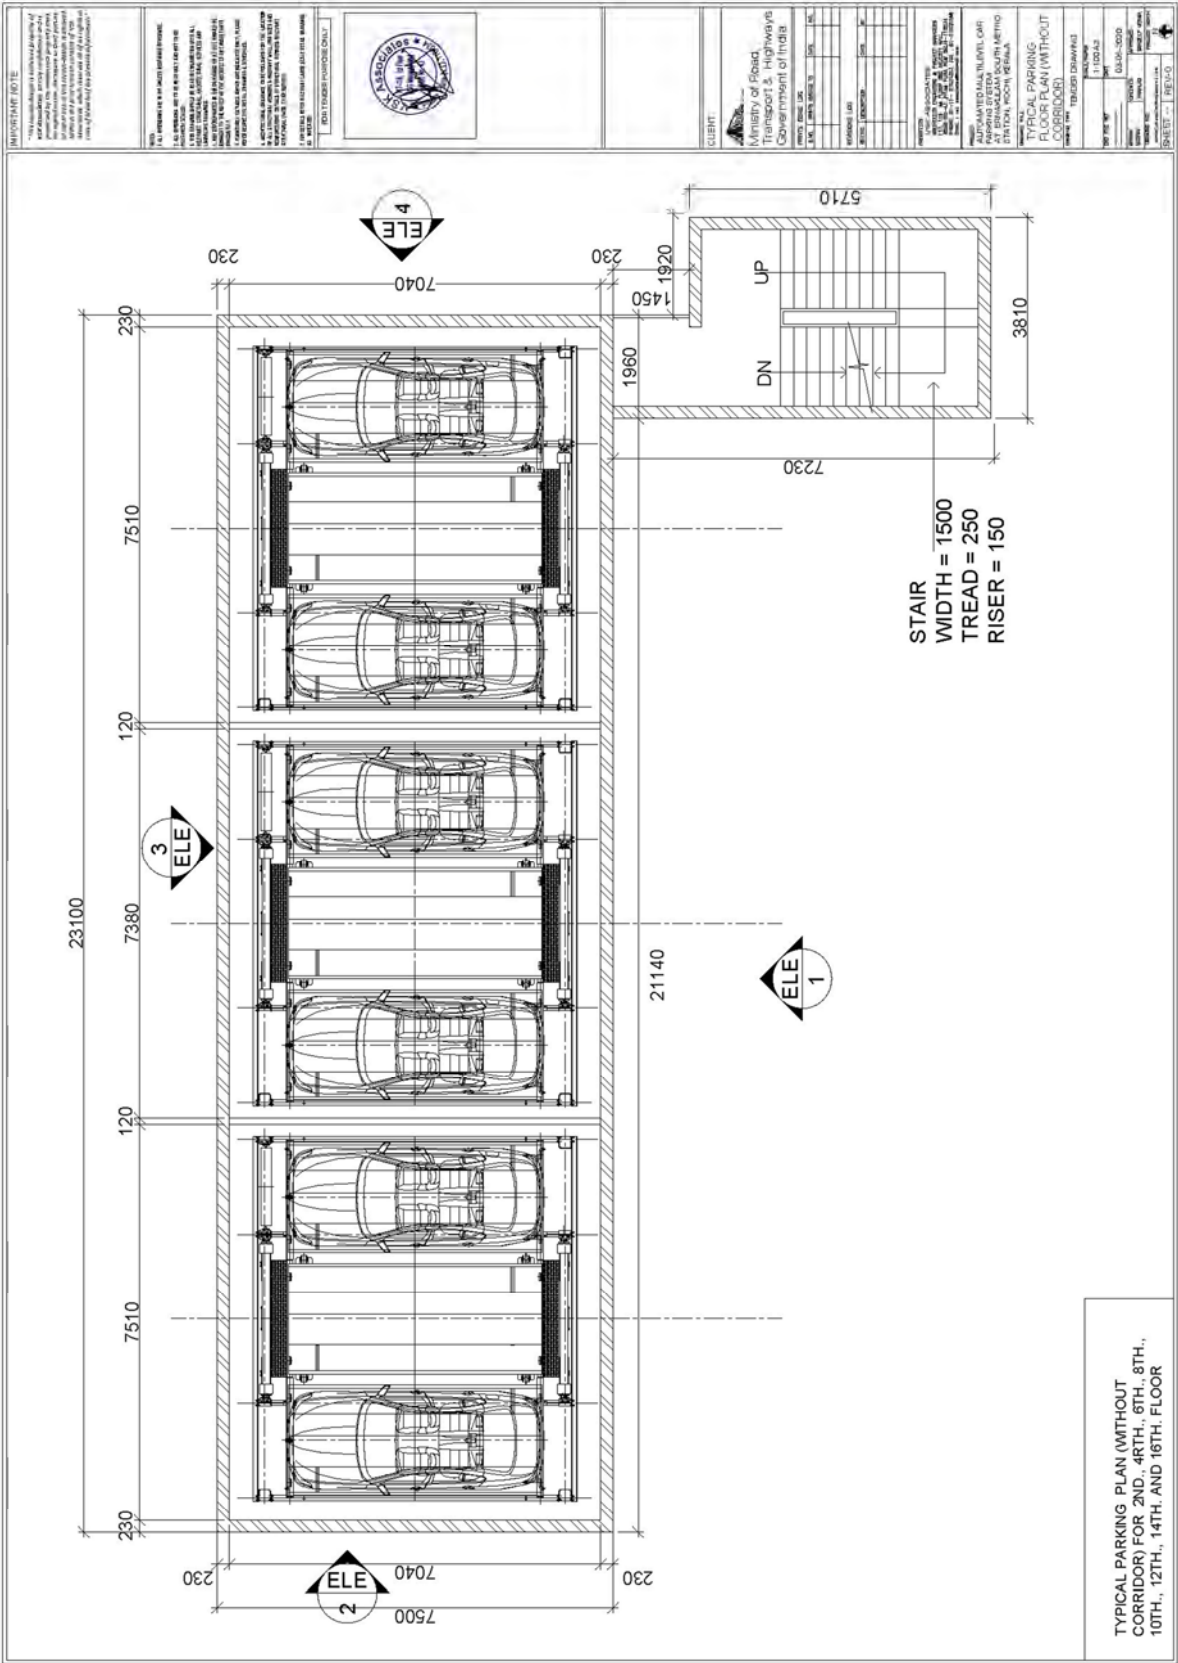


SECTION IV BIDDING FORMS: Schedules

ADDITIONAL APPENDIX C (DRAWINGS)

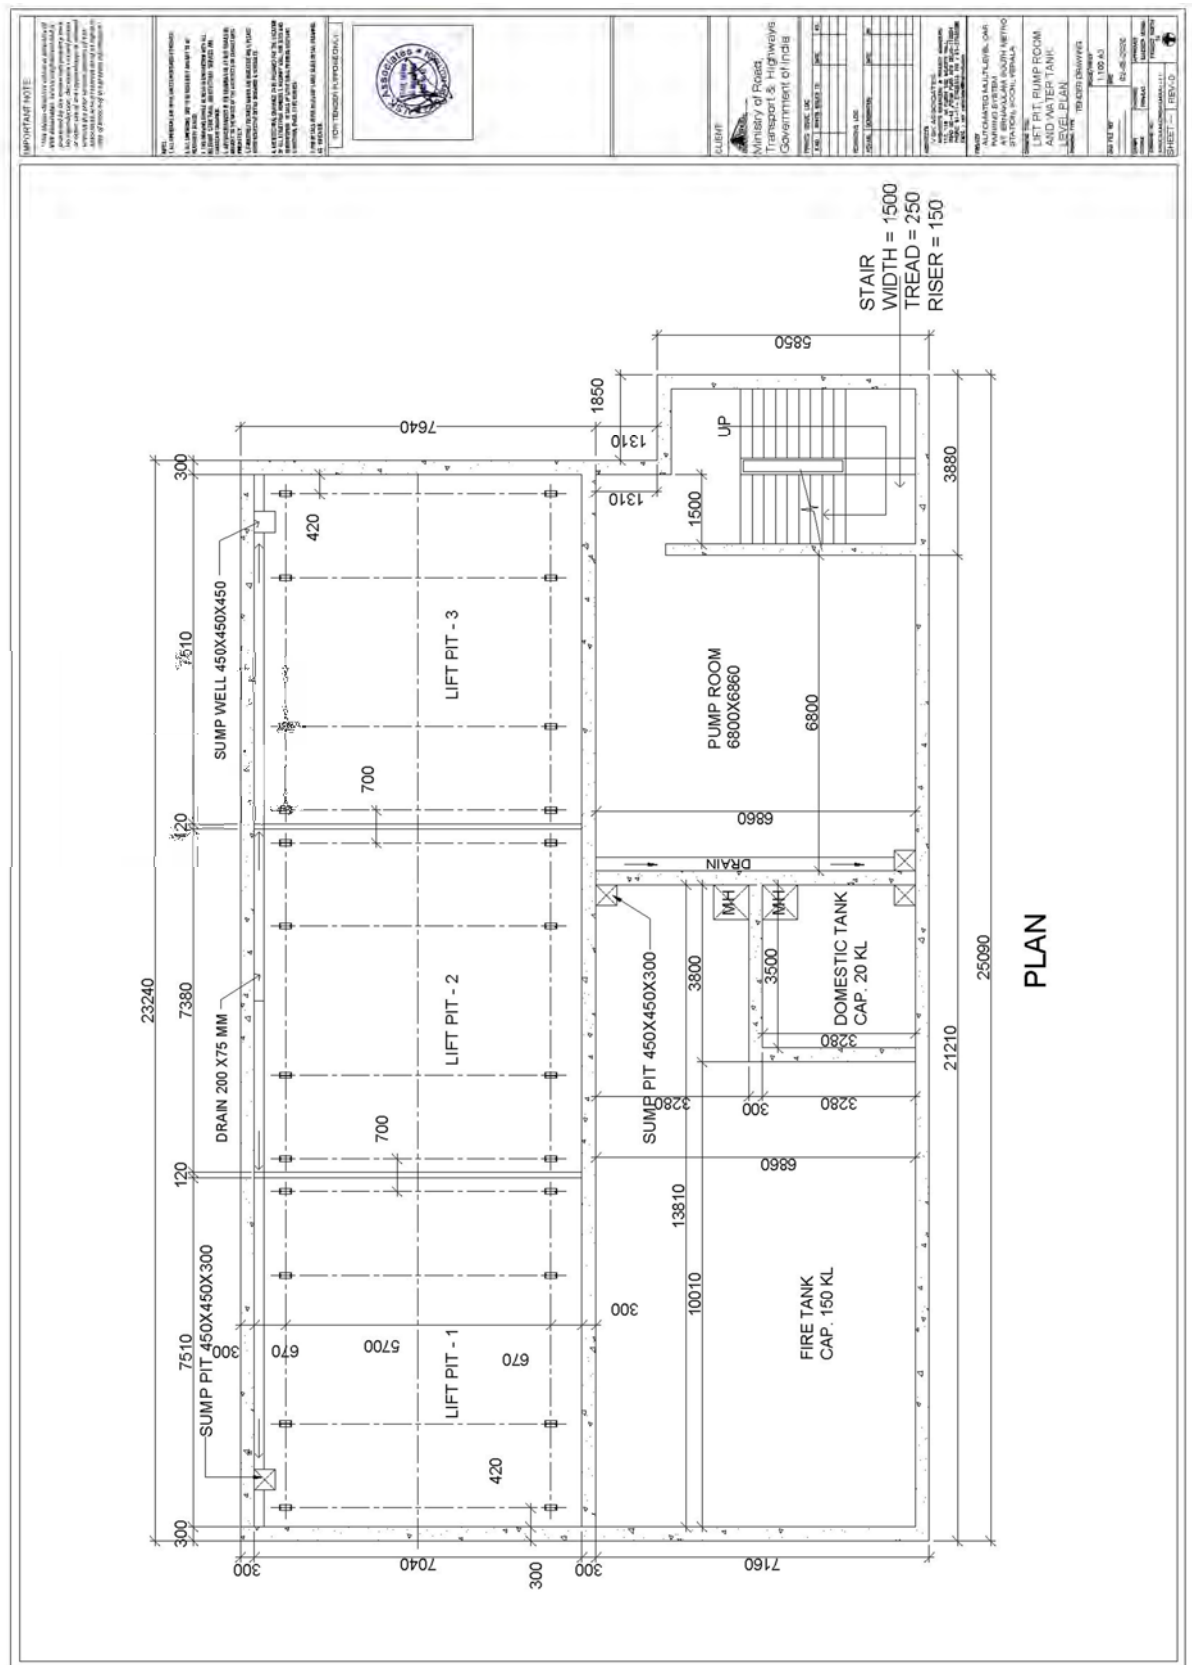


SECTION IV BIDDING FORMS: Schedules

ADDITIONAL APPENDIX C (DRAWINGS)

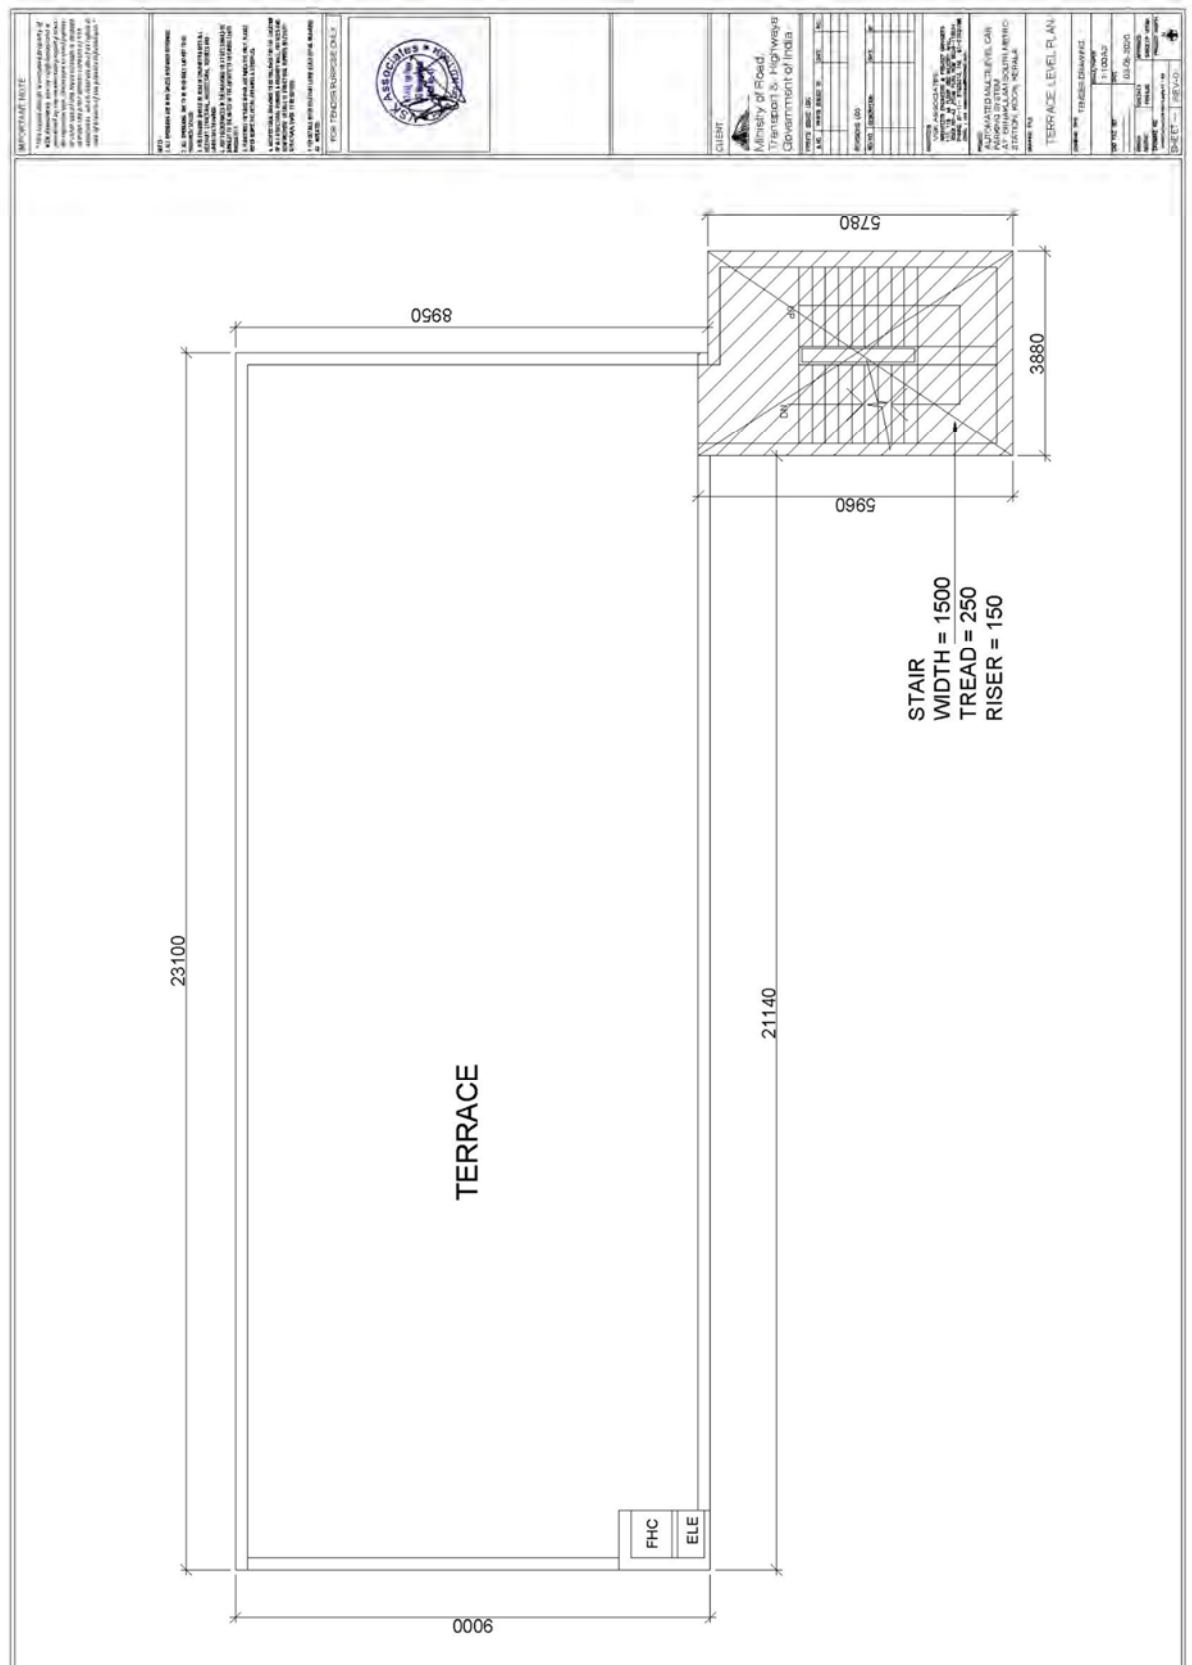

SECTION IV BIDDING FORMS: Schedules

 
ADDITIONAL APPENDIX C (DRAWINGS)







SECTION IV BIDDING FORMS: Schedules

ADDITIONAL APPENDIX C (DRAWINGS)

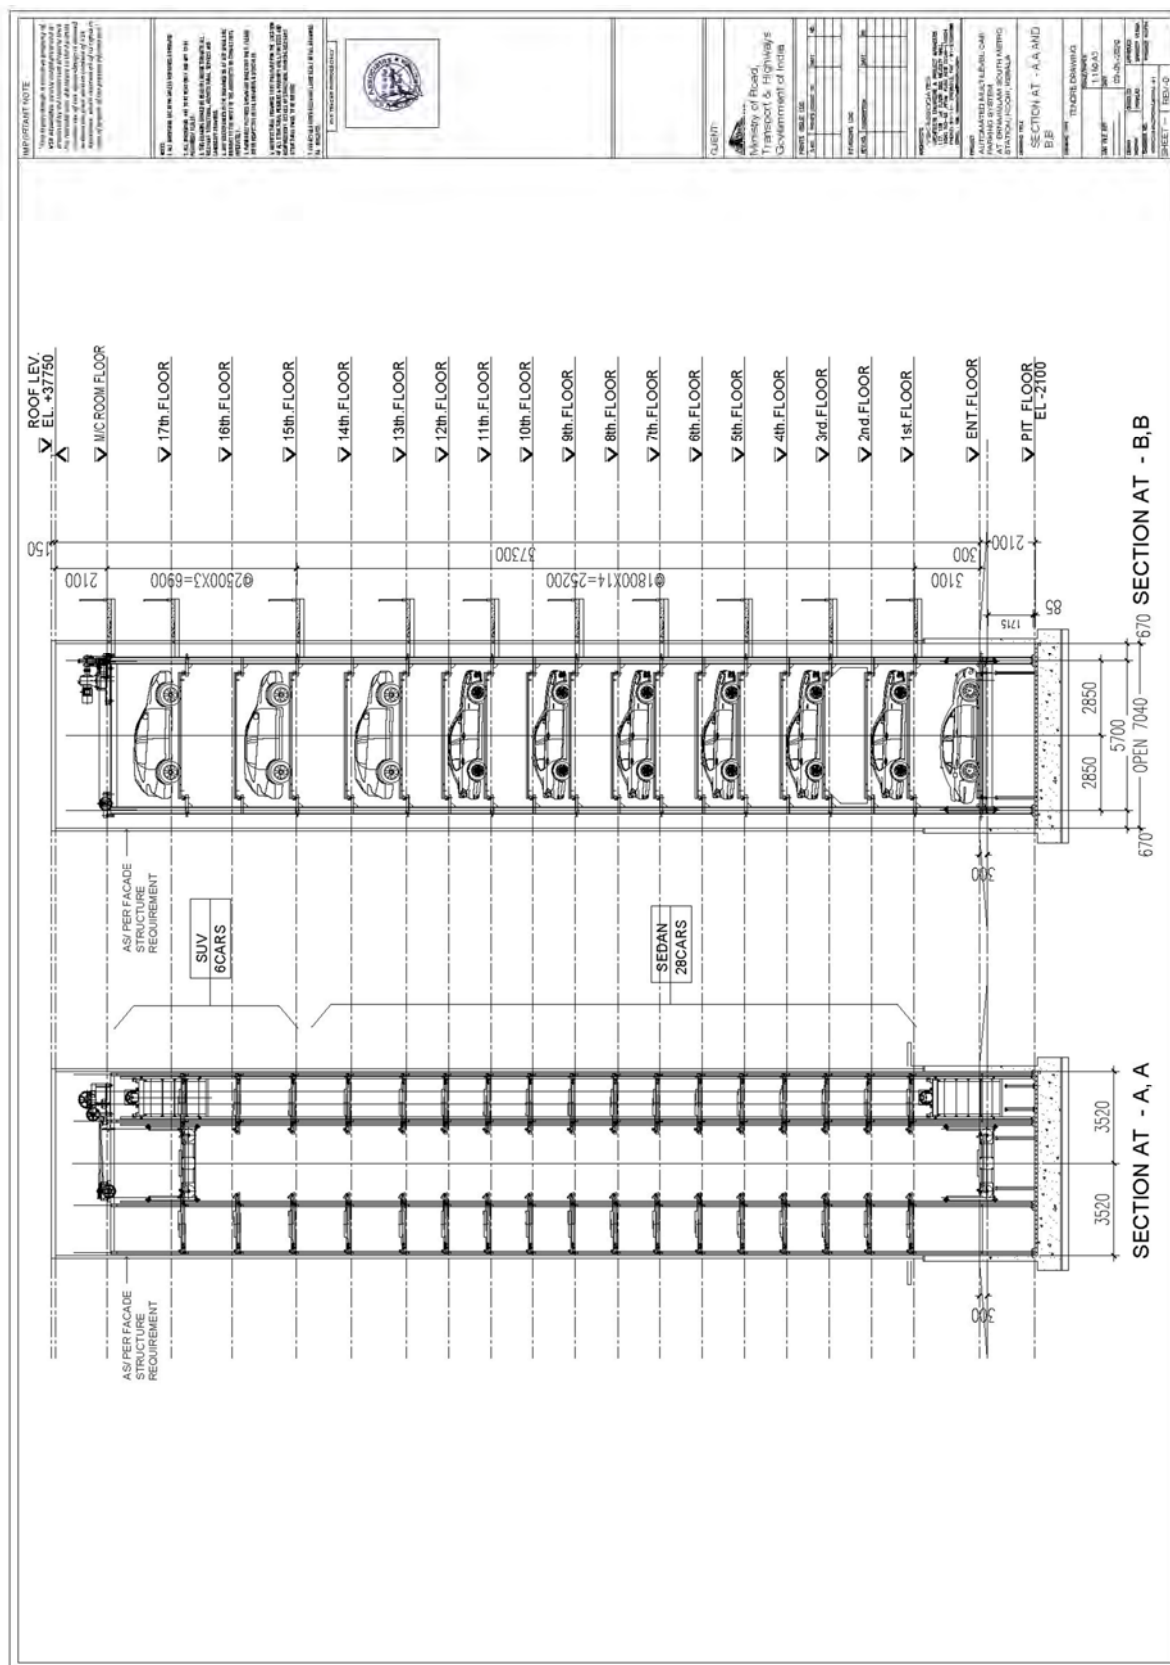


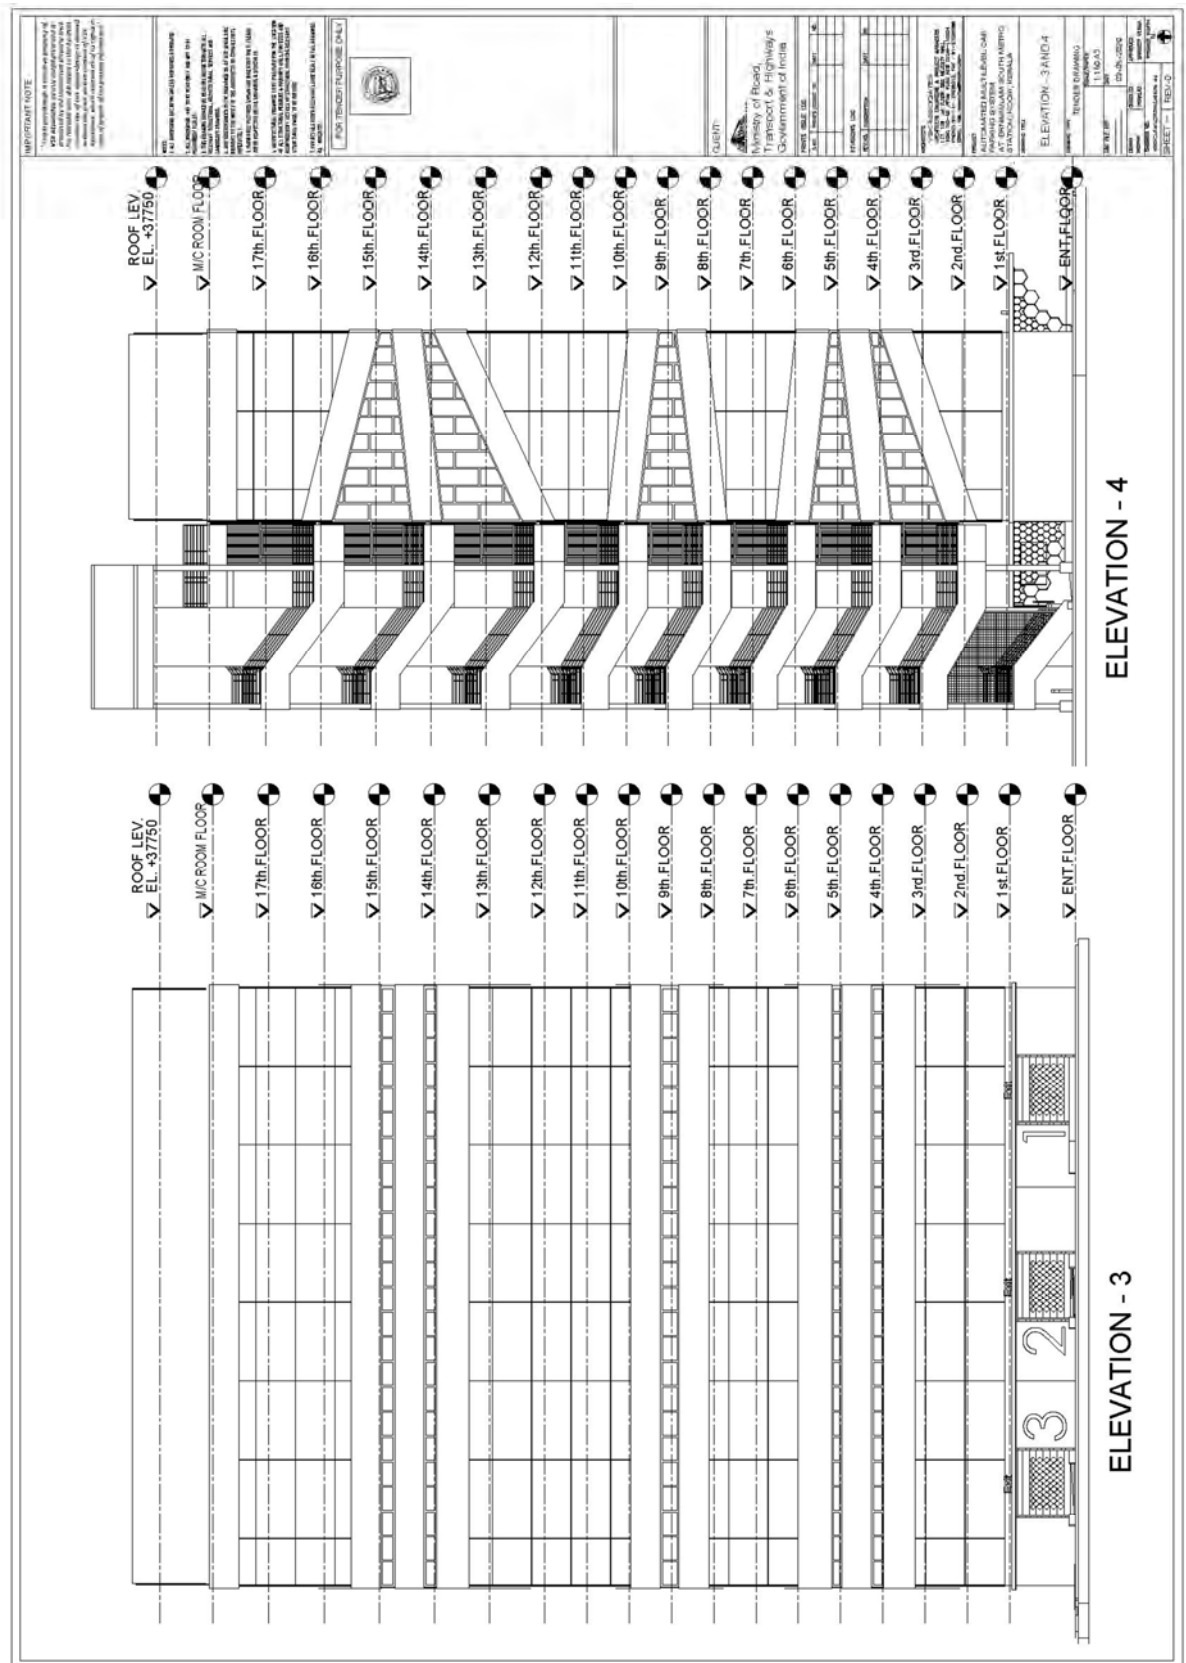



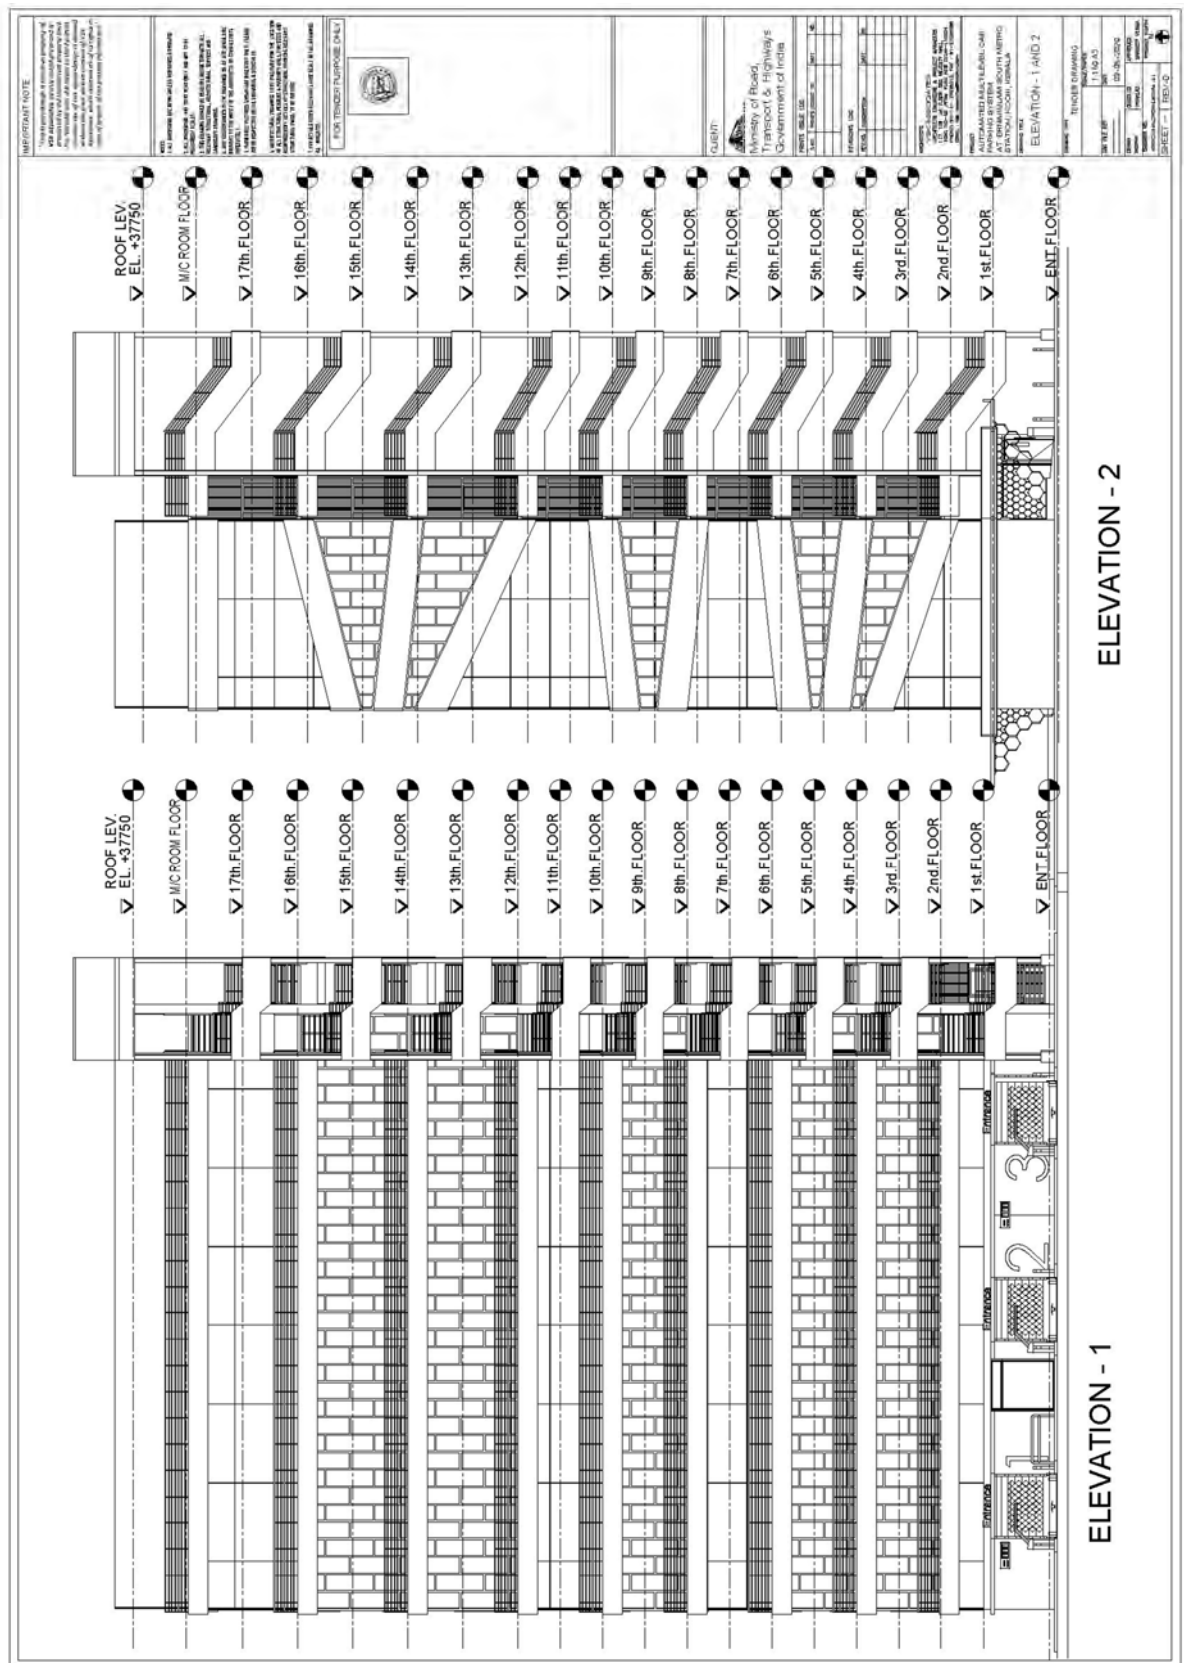


PROPOSED AUTOMATED MULTI LEVEL CAR PARKING AT ERNAKULAM SOUTH METRO STATION KOCHIN KERALA			
LIST OF DRAWINGS			
STRUCURAL DRAWING			
S.NO.	DRAWING TITLE	DRAWING NO.	REMARK
1	PILE AND FOUNATION LAYOUT PLAN	NHIDCL/AMLCP/ENKLM/STR S - 01	PILE AND FOUNATION LAYOUT PLAN
2	PILE DETAILS	NHIDCL/AMLCP/ENKLM/STR/S - 02	DETAILS
3	STRCTURAL ELEVATION	NHIDCL/AMLCP/ENKLM/STR/S -3	ELEVATION

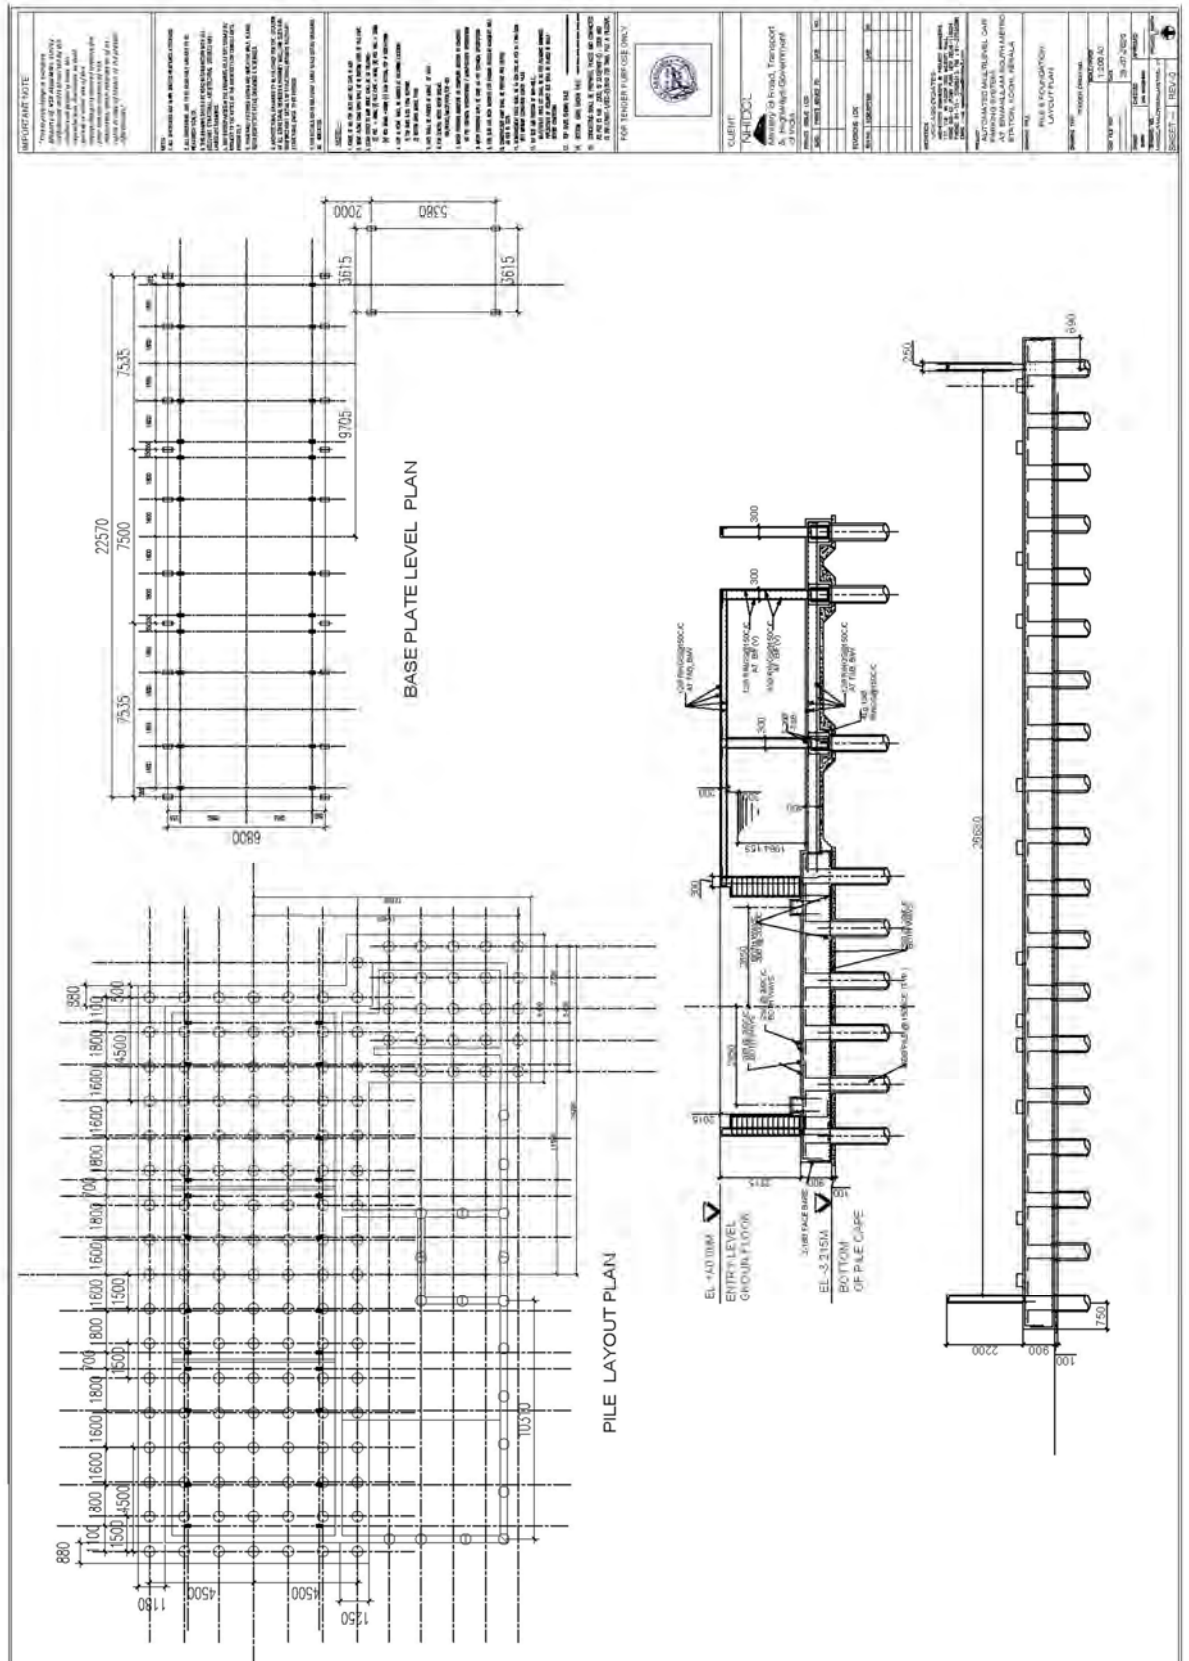


SECTION IV BIDDING FORMS: Schedules

ADDITIONAL APPENDIX C (DRAWINGS)

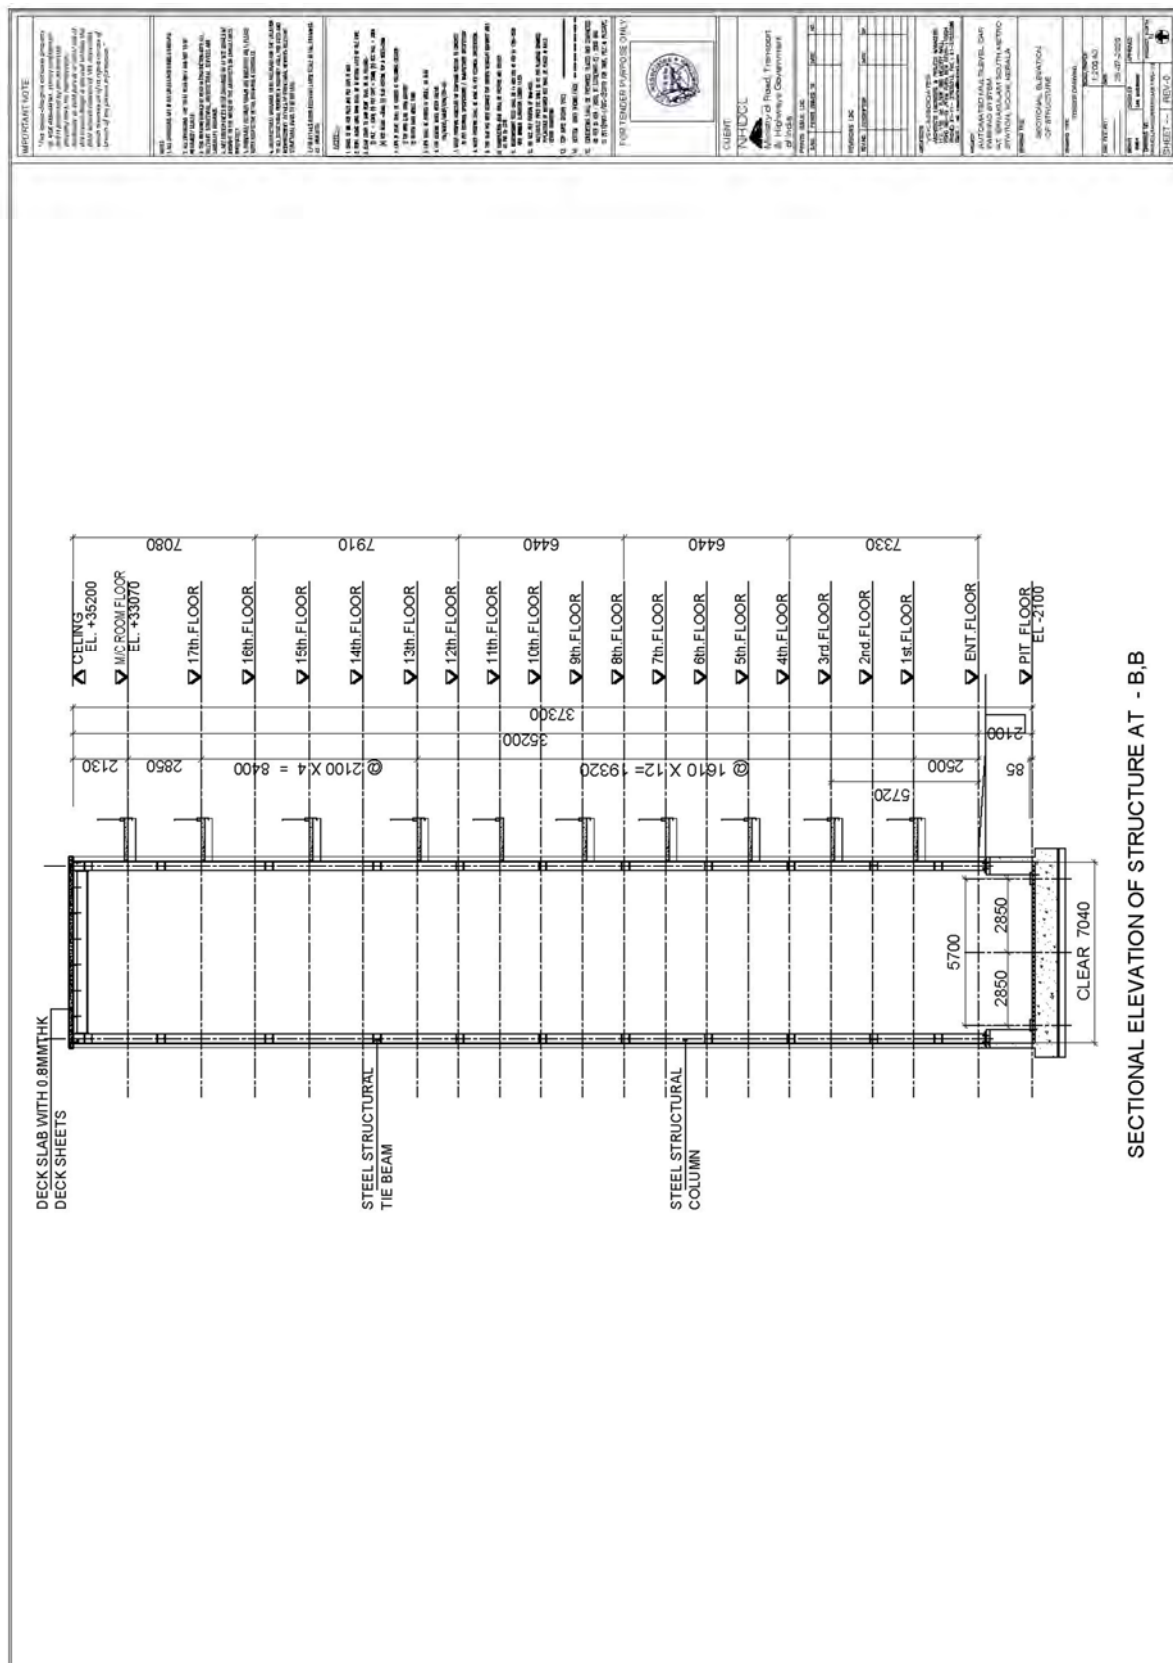

SECTION IV BIDDING FORMS: Schedules

ADDITIONAL APPENDIX C (DRAWINGS)

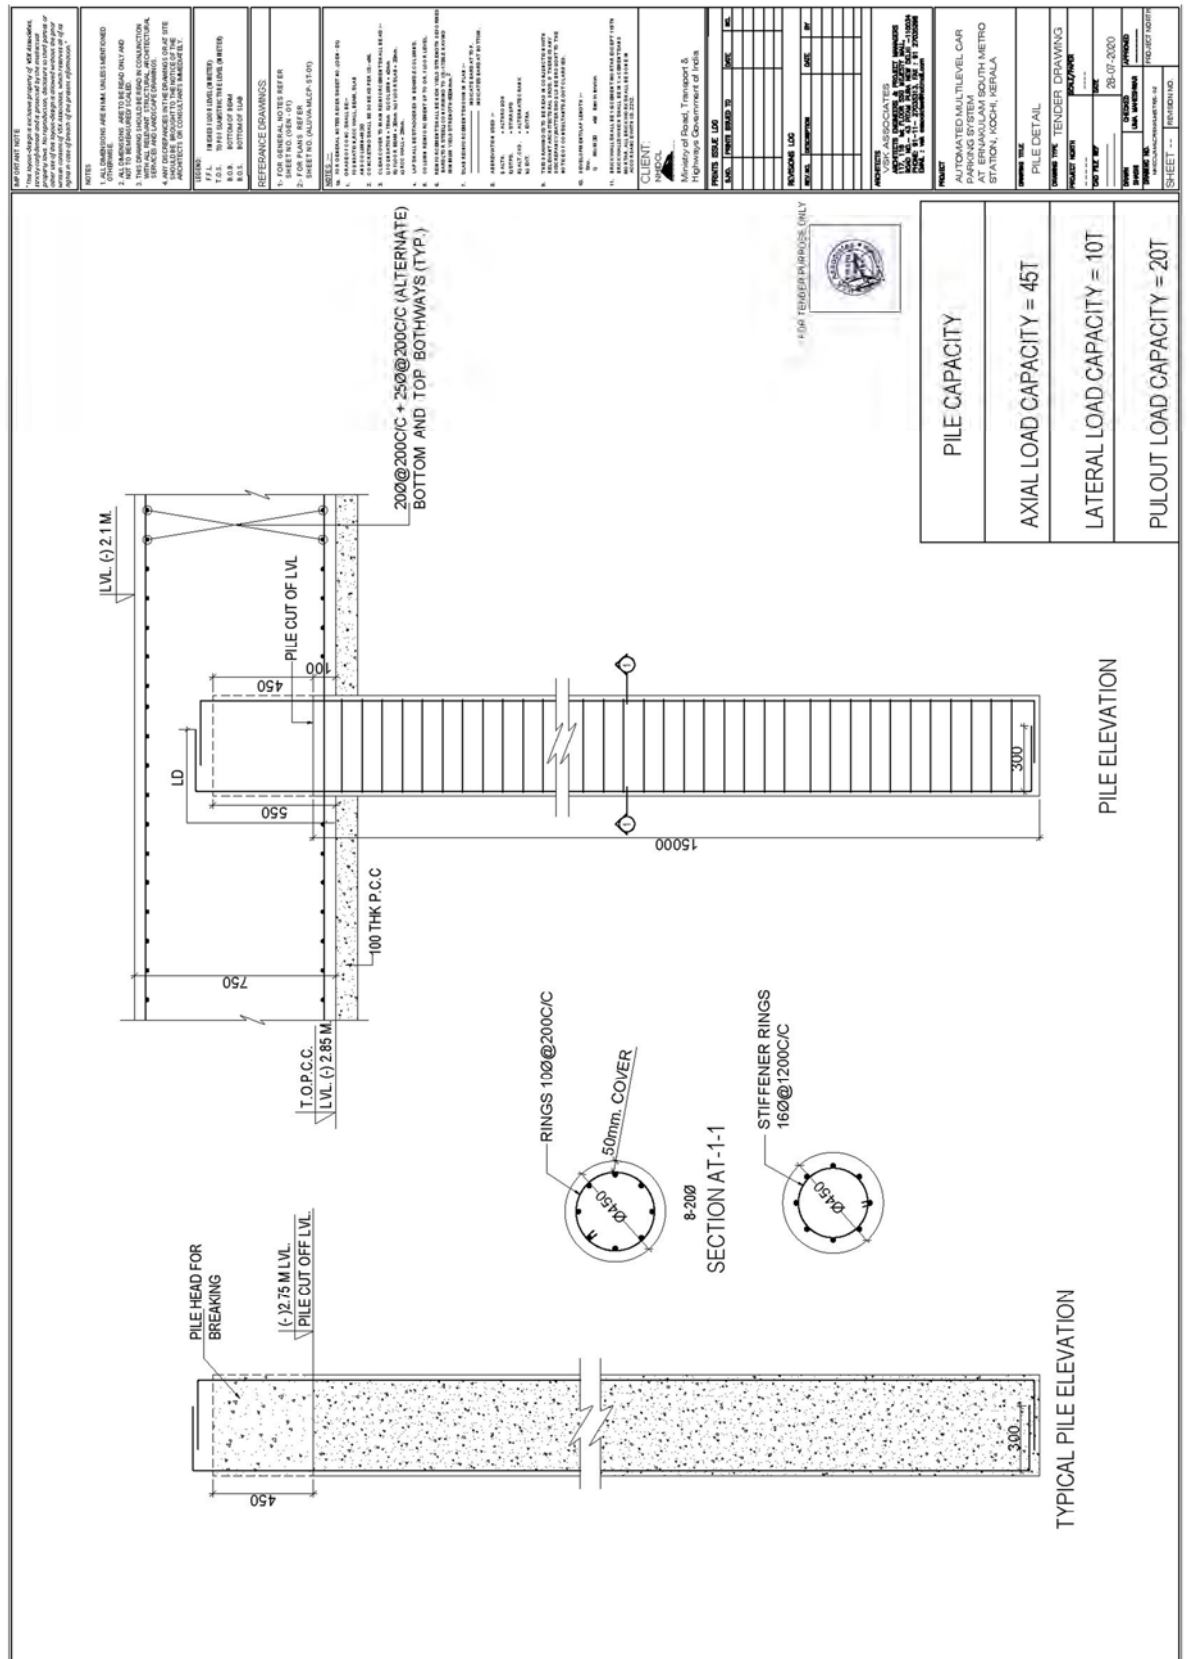

## Automated Multilevel Car Parking Facility at ERNAKULAM SOUTH Metro Station, Kochi

SECTION IV BIDDING FORMS: Schedules

ADDITIONAL APPENDIX C (DRAWINGS)

[illegible]

SECTION IV BIDDING FORMS: Schedules

ADDITIONAL APPENDIX C (DRAWINGS)








SECTION IV BIDDING FORMS: Schedules


ADDITIONAL APPENDIX C (DRAWINGS)

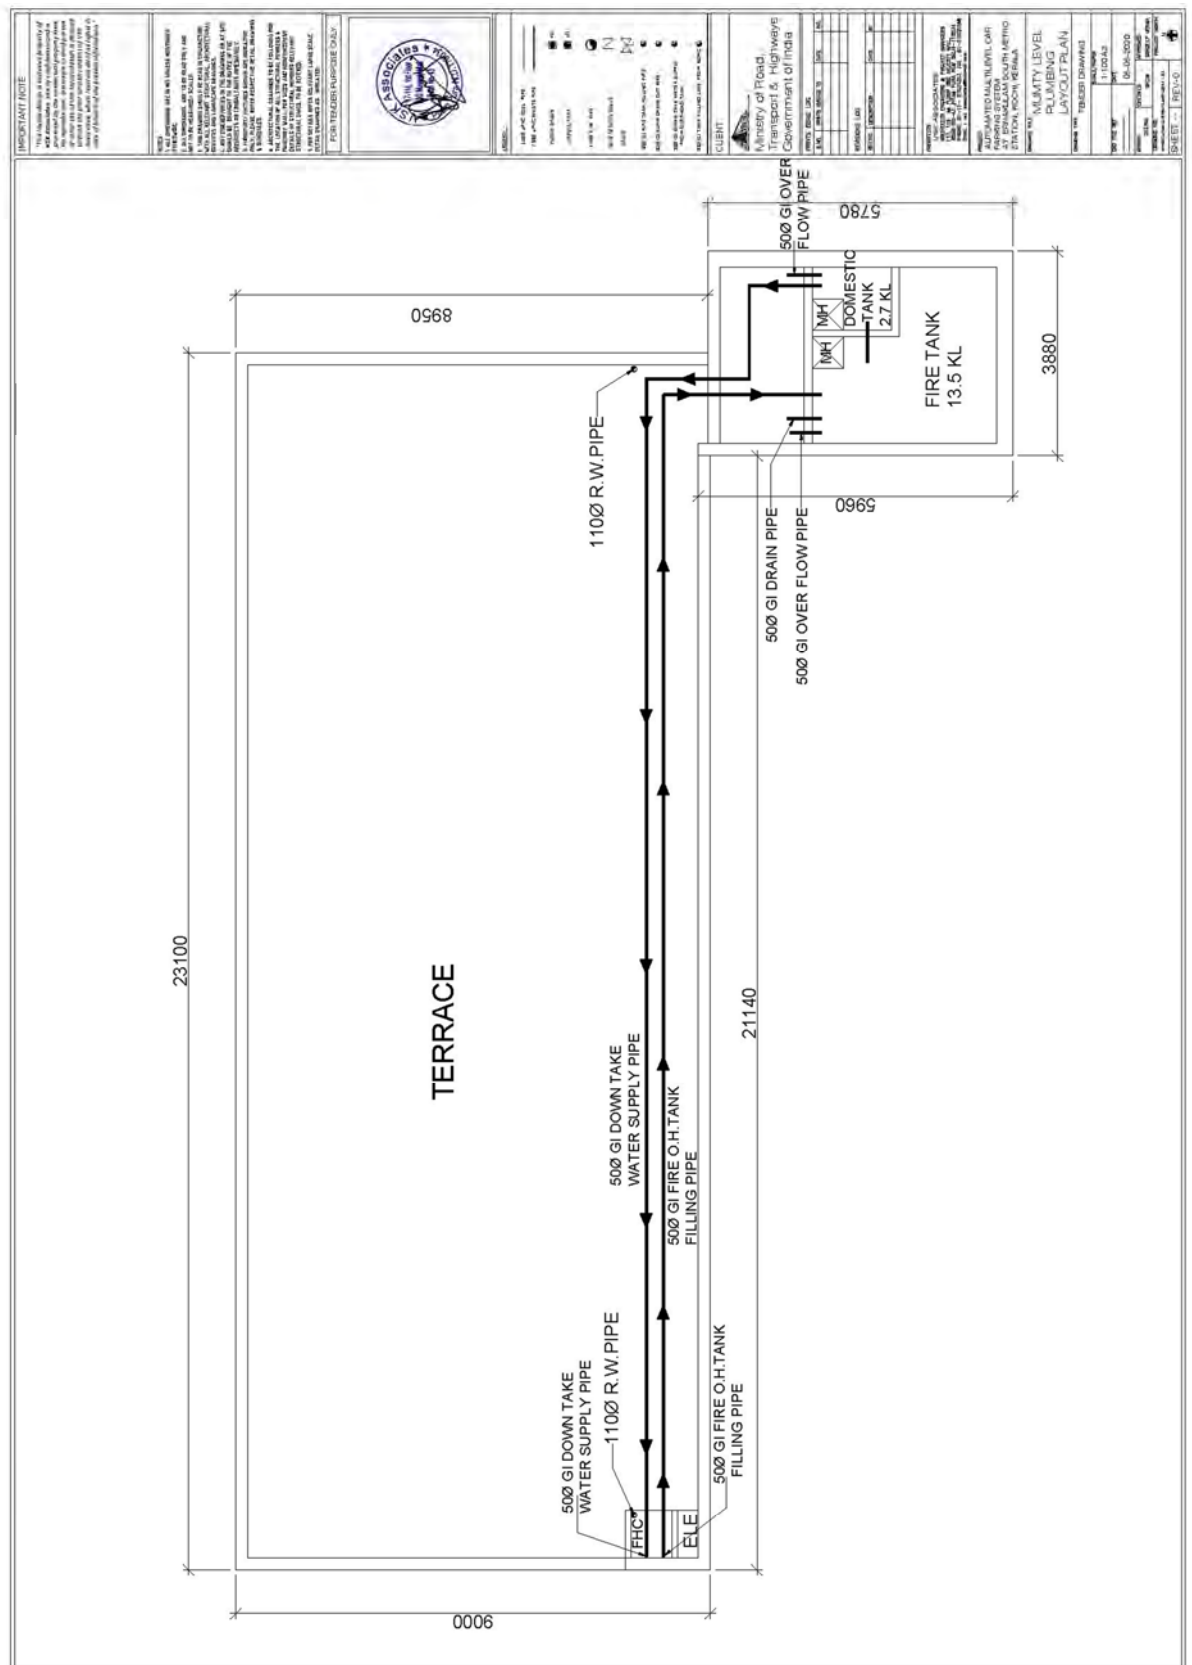


Automated Multilevel Car Parking Facility at ERNAKULAM  
SOUTH Metro Station, Kochi

SECTION IV BIDDING FORMS: Schedules  
ADDITIONAL APPENDIX C (DRAWINGS)


<b><u>PROPOSED AUTOMATED MULTI LEVEL CAR PARKING AT ERNAKULAM SOUTH METRO STATION KOCHIN KERALA</u></b>			
<b><u>LIST OF DRAWINGS</u></b>			
<b><u>ELECTRICAL DRAWINGS (FLOOR PLANS)</u></b>			
1	LIFT PIT, PUMP ROOM AND WATER TANK ELECTRICAL LAYOUT	NHIDCL/AMLCP/ENKLM/EL/A1 - 01	
2	GROUND FLOOR ELECTRICAL PLAN (ENTRY AND EXIT LEVEL)	NHIDCL/AMLCP/ENKLM/EL/A1 - 02	
3	TYPICAL PARKING ELECTRICAL FLOOR PLAN (WITH CORRIDOR)	NHIDCL/AMLCP/ENKLM/EL/A1 - 03	
4	TYPICAL PARKING ELECTRICAL FLOOR PLAN (WITHOUT CORRIDOR)	NHIDCL/AMLCP/ENKLM/EL/A1 - 04	
5	TERRACE LEVEL ELECTRICAL PLAN	NHIDCL/AMLCP/ENKLM/EL/A1 - 05	
6	DB FOR TOWER-1,2 &3 SLD	NHIDCL/AMLCP/ENKLM/EL/A3 - 06	
7	DB FOR PUMP ROOM/ ELECTRICAL ROOM & STAIRCASE SLD	NHIDCL/AMLCP/ENKLM/EL/A3 - 07	
8	MAIN LT PANEL SLD	NHIDCL/AMLCP/ENKLM/EL/A3 - 08	
9	FIRE ALARM SCHEMATIC DRAWING	NHIDCL/AMLCP/ENKLM/FAS/A3 - 09	

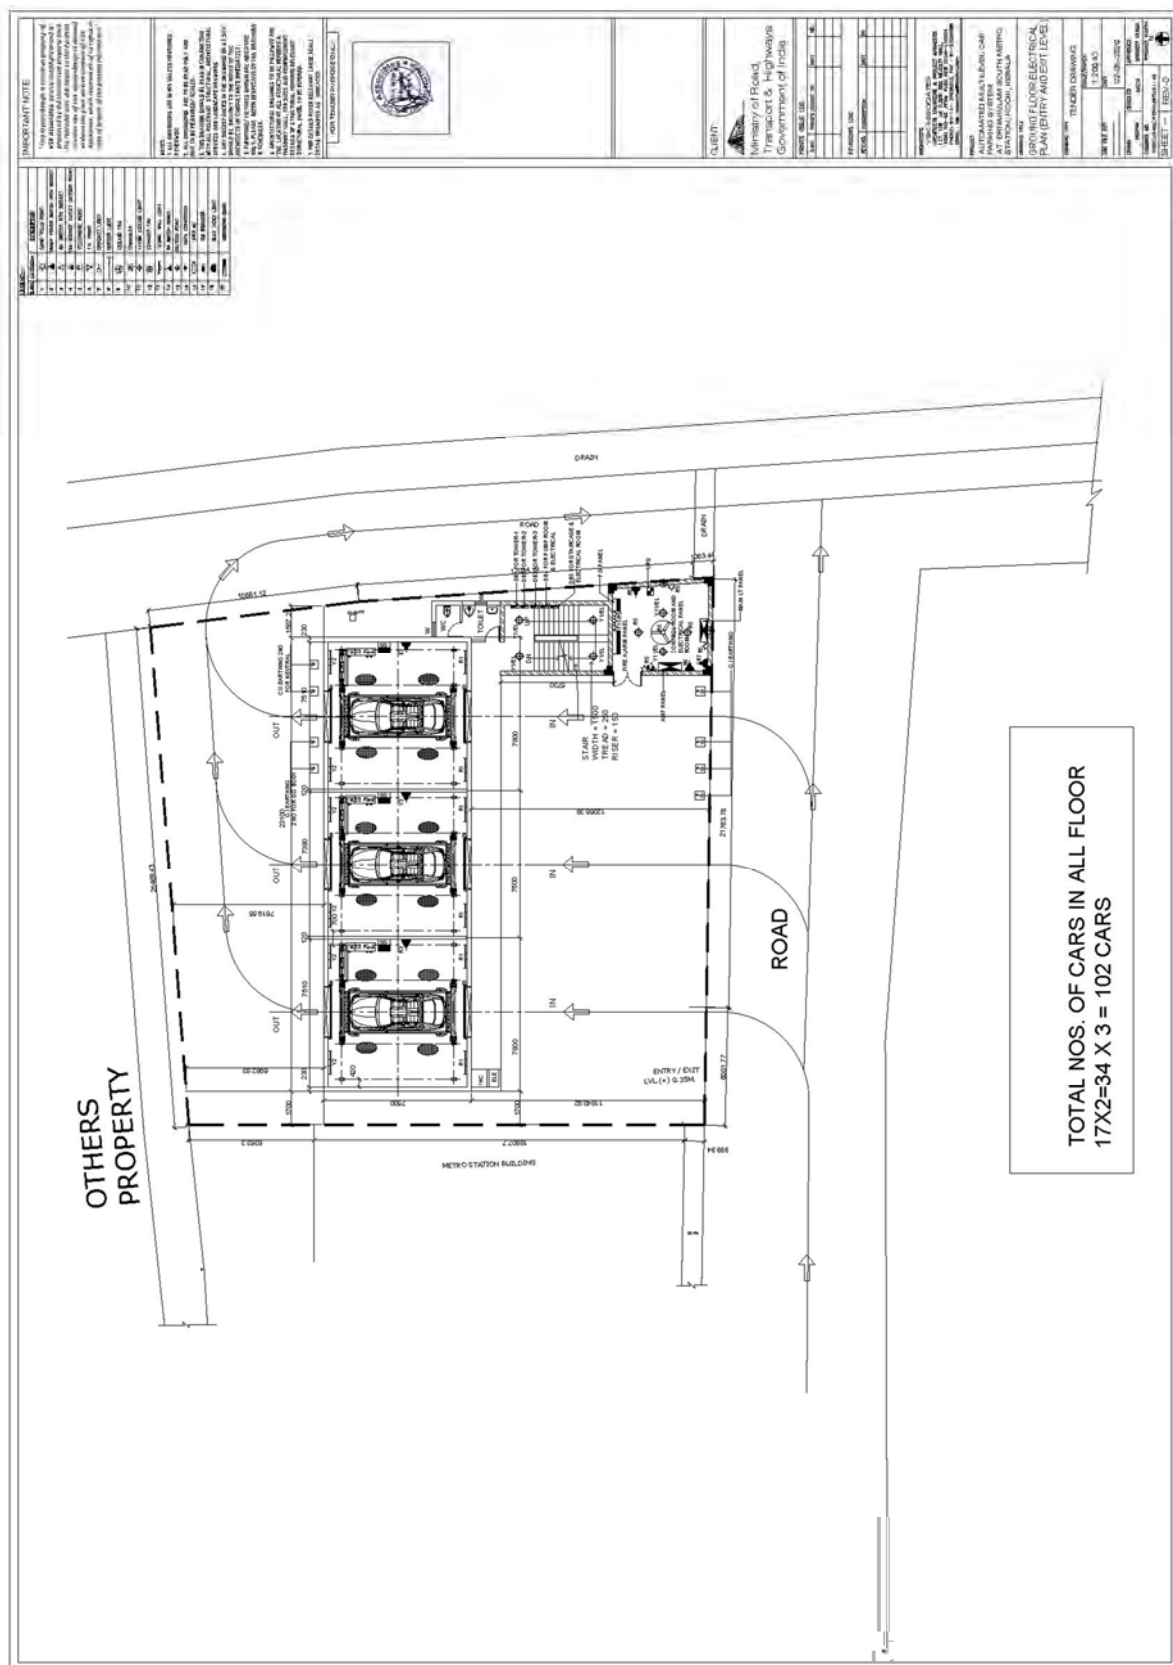

 

SECTION IV BIDDING FORMS: Schedules

 
ADDITIONAL APPENDIX C (DRAWINGS)





SECTION IV BIDDING FORMS: Schedules


ADDITIONAL APPENDIX C (DRAWINGS)

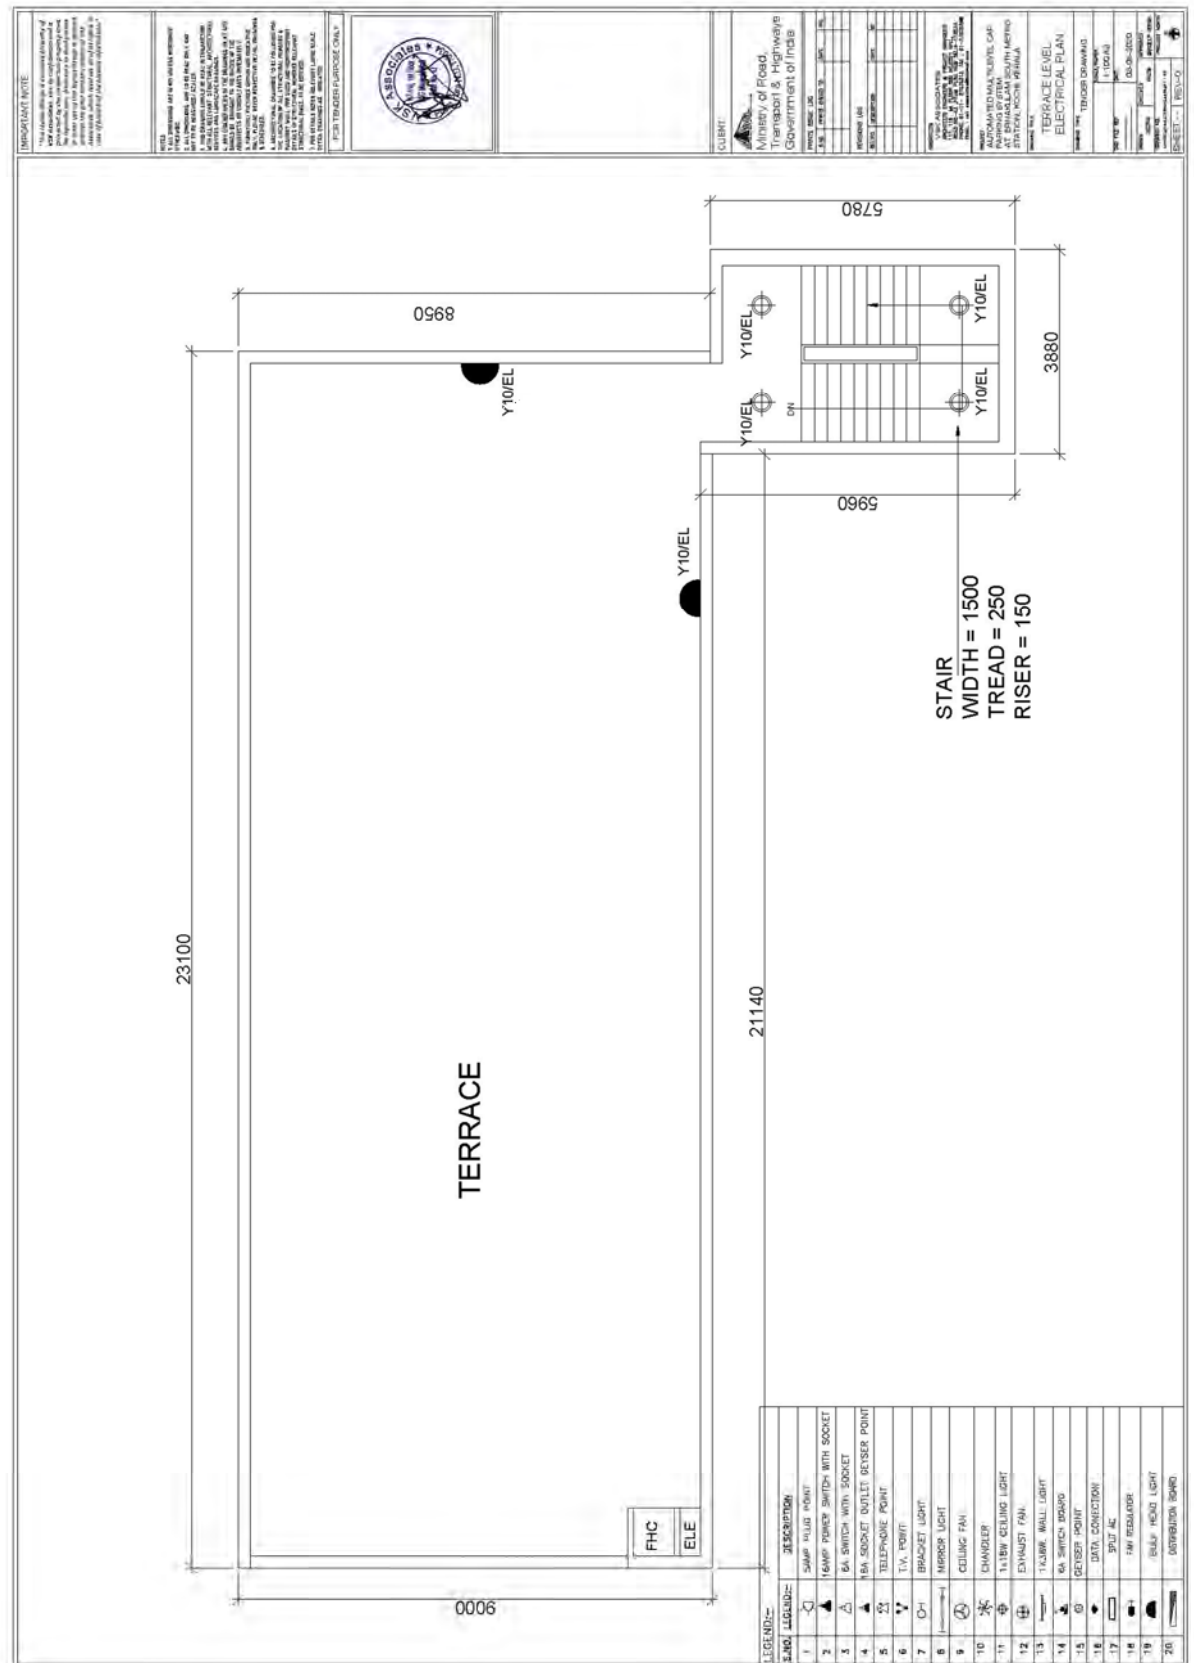





SECTION IV BIDDING FORMS: Schedules

ADDITIONAL APPENDIX C (DRAWINGS)

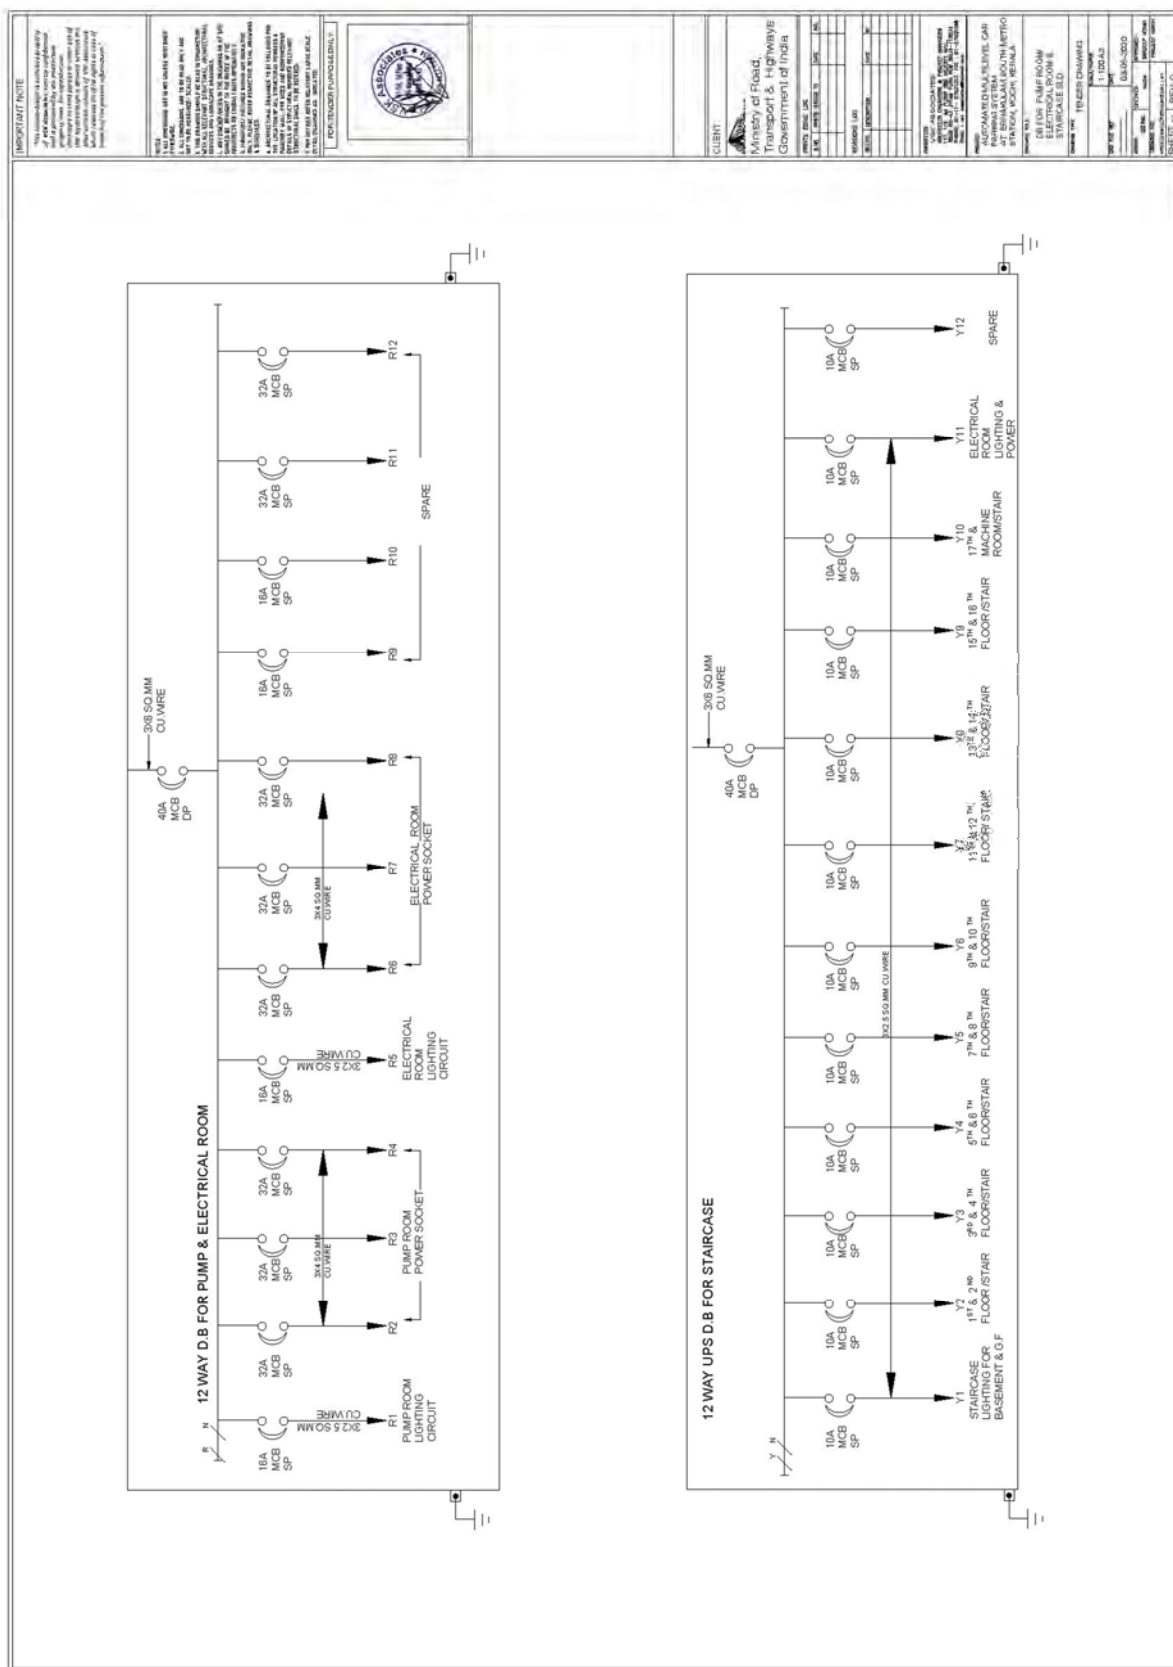




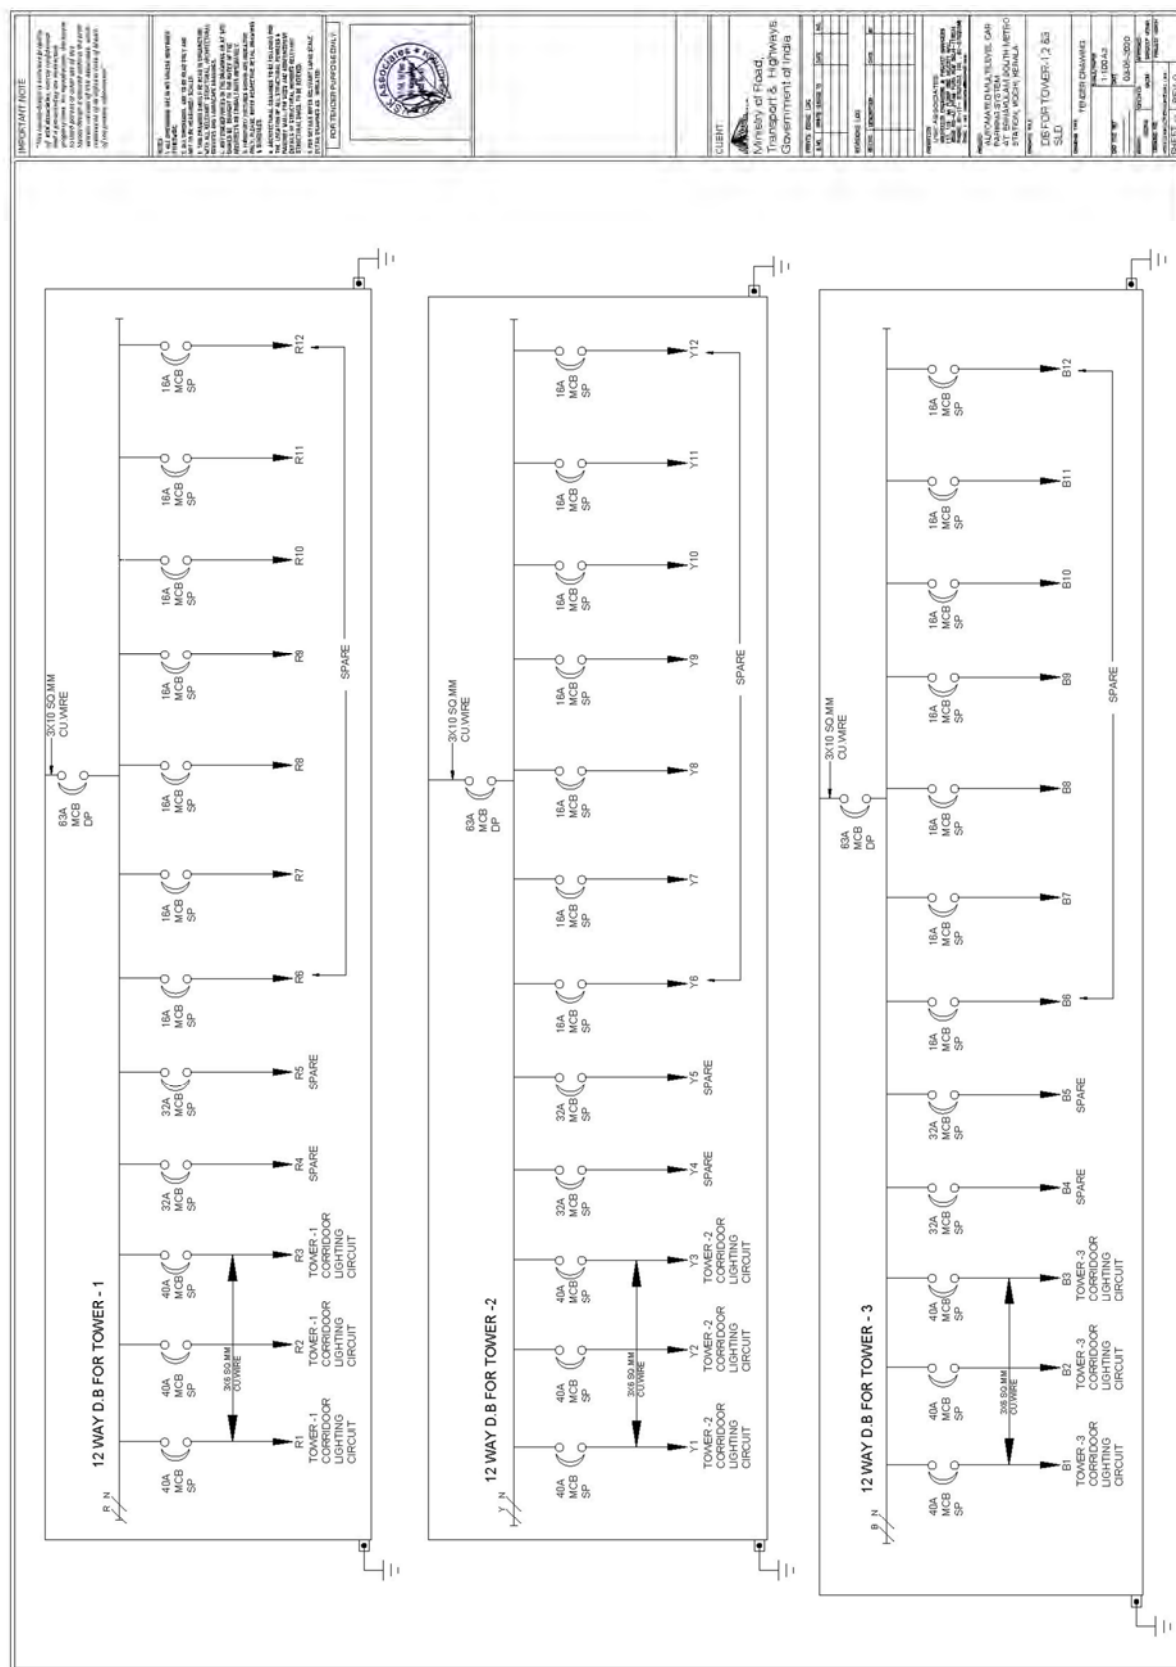

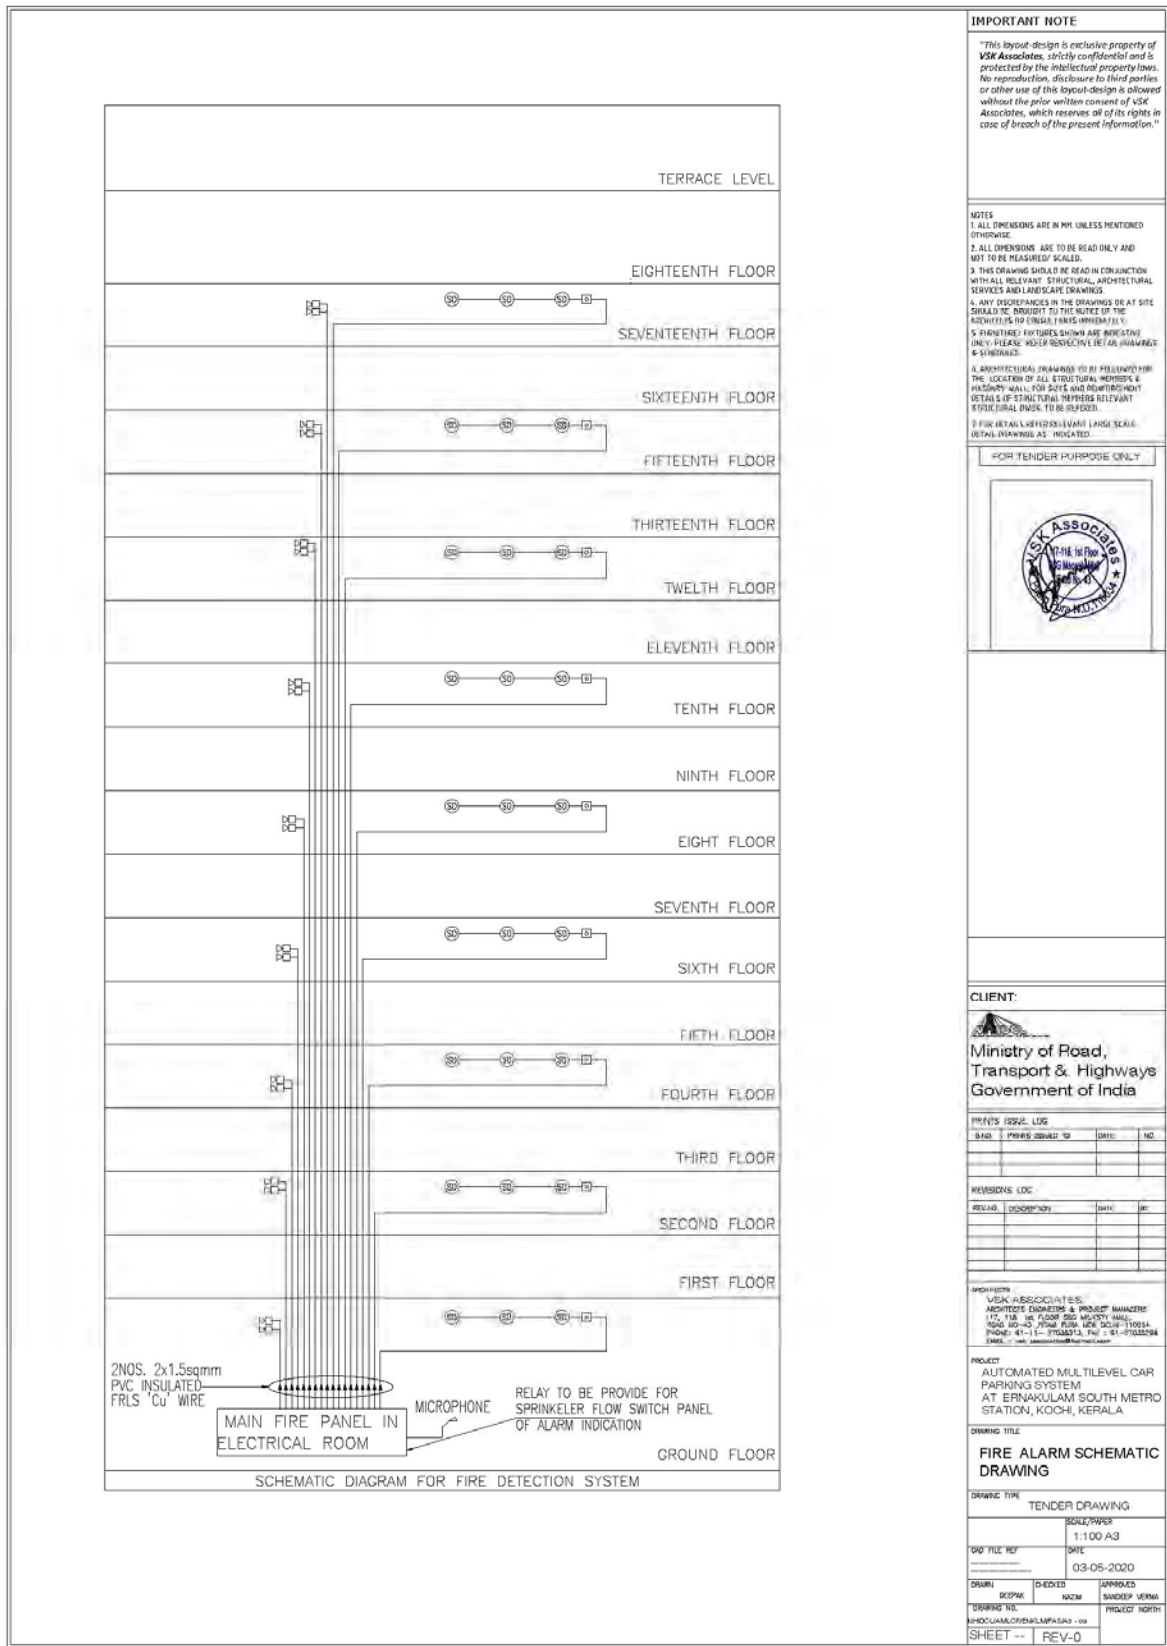


SECTION IV BIDDING FORMS: Schedules

ADDITIONAL APPENDIX C (DRAWINGS)

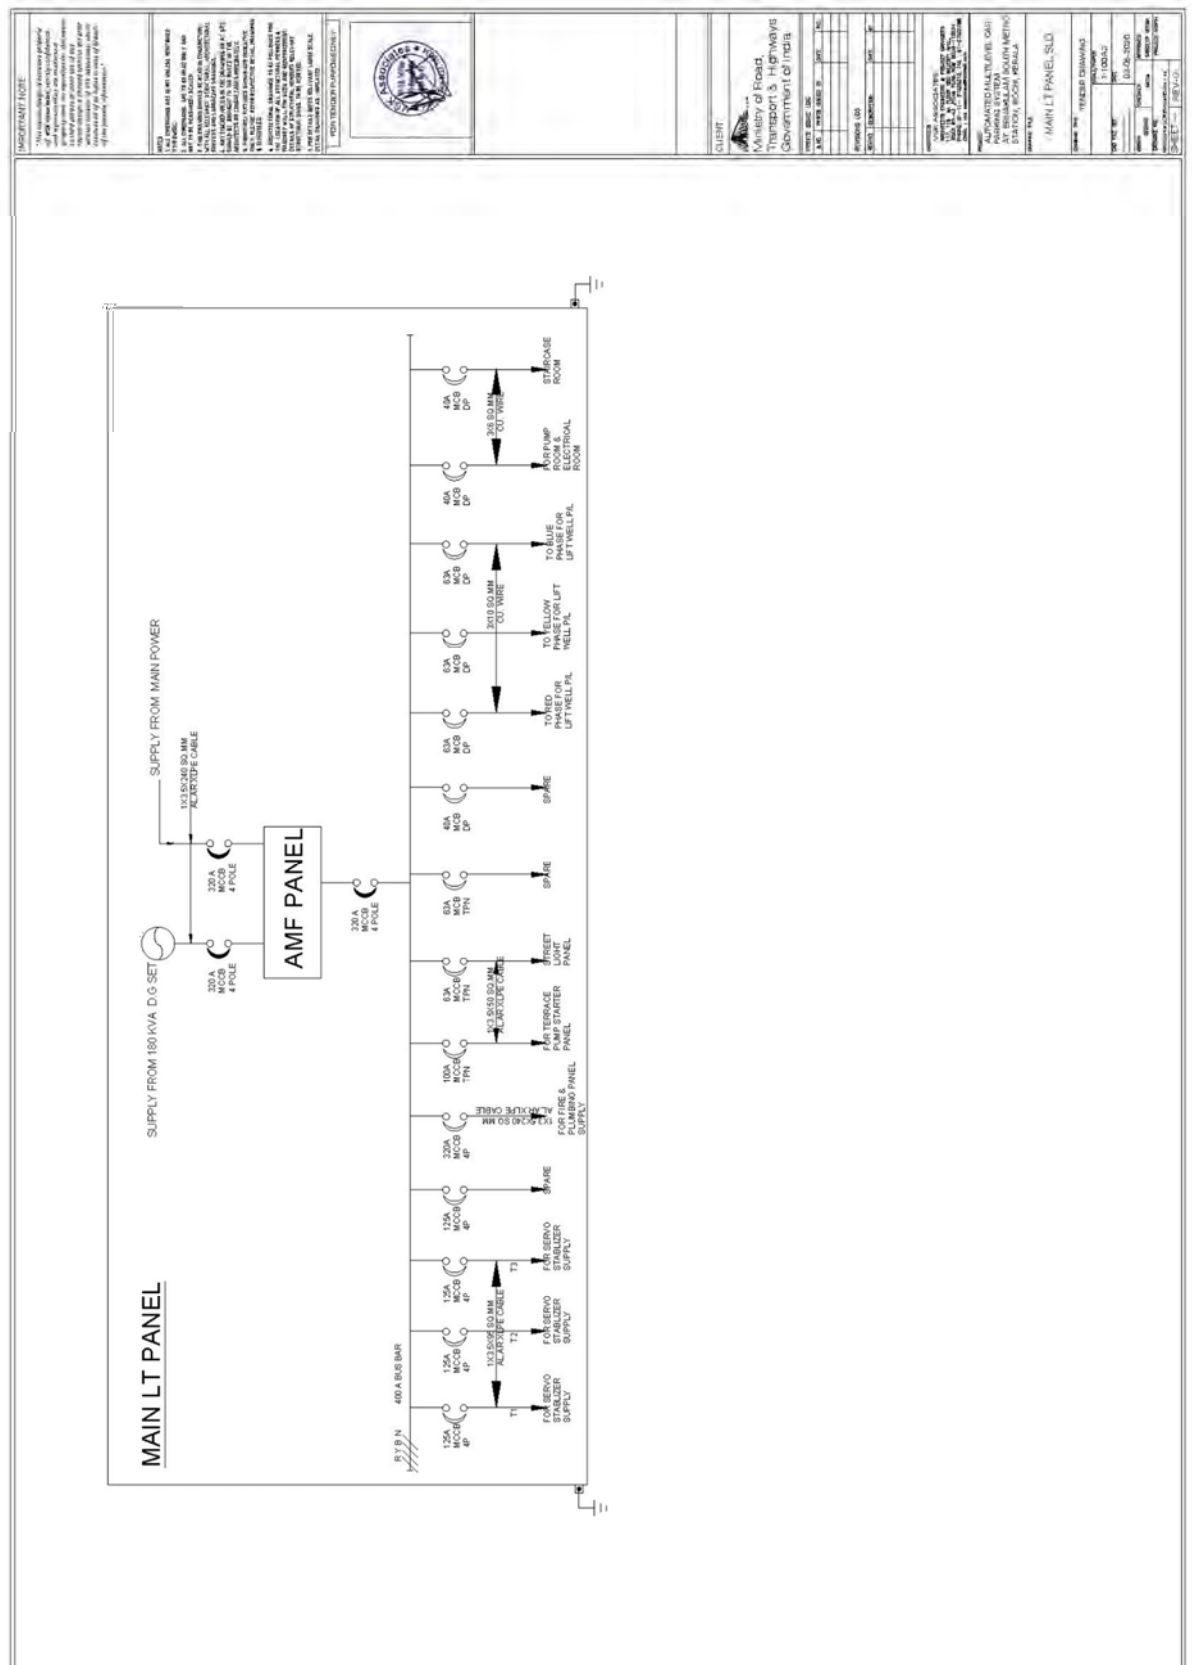

<b><u>PROPOSED AUTOMATED MULTI LEVEL CAR PARKING AT ERNAKULAM SOUTH METRO STATION KOCHIN KERALA</u></b>			
<b><u>LIST OF DRAWINGS</u></b>			
<b><u>FIRE FIGHTING DRAWINGS (FLOOR PLANS)</u></b>			
1	FIRE FIGHTING PUMP ROOM AND WATER TANK LEVEL PLAN	NHIDCL/AMLCP/ENKLM/FF/A1 - 01	
2	FIRE SPRINKLER AND HYDRANT LAYOUT ENTRY AND EXIT LEVEL PLAN	NHIDCL/AMLCP/ENKLM/FF/A1 - 02	ENTRY AND EXIT LEVEL PLAN
3	TYPICAL PARKING SPRINKLER PLAN (WITH CORRIDOR)	NHIDCL/AMLCP/ENKLM/FF/A1 - 03	
4	TYPICAL PARKING SPRINKLER PLAN (WITHOUT CORRIDOR)	NHIDCL/AMLCP/ENKLM/FF/A1 - 04	
5	TERRACE LEVEL FIRE HYDRANT PLAN	NHIDCL/AMLCP/ENKLM/FF/A1 - 05	
6	MUMTY LEVEL FIRE HYDRANT PLAN	NHIDCL/AMLCP/ENKLM/FF/A1 - 06	WATER TANK LEVEL
7	SINGLE LINE DIAGRAM	NHIDCL/AMLCP/ENKLM/FF/A1 - 07	



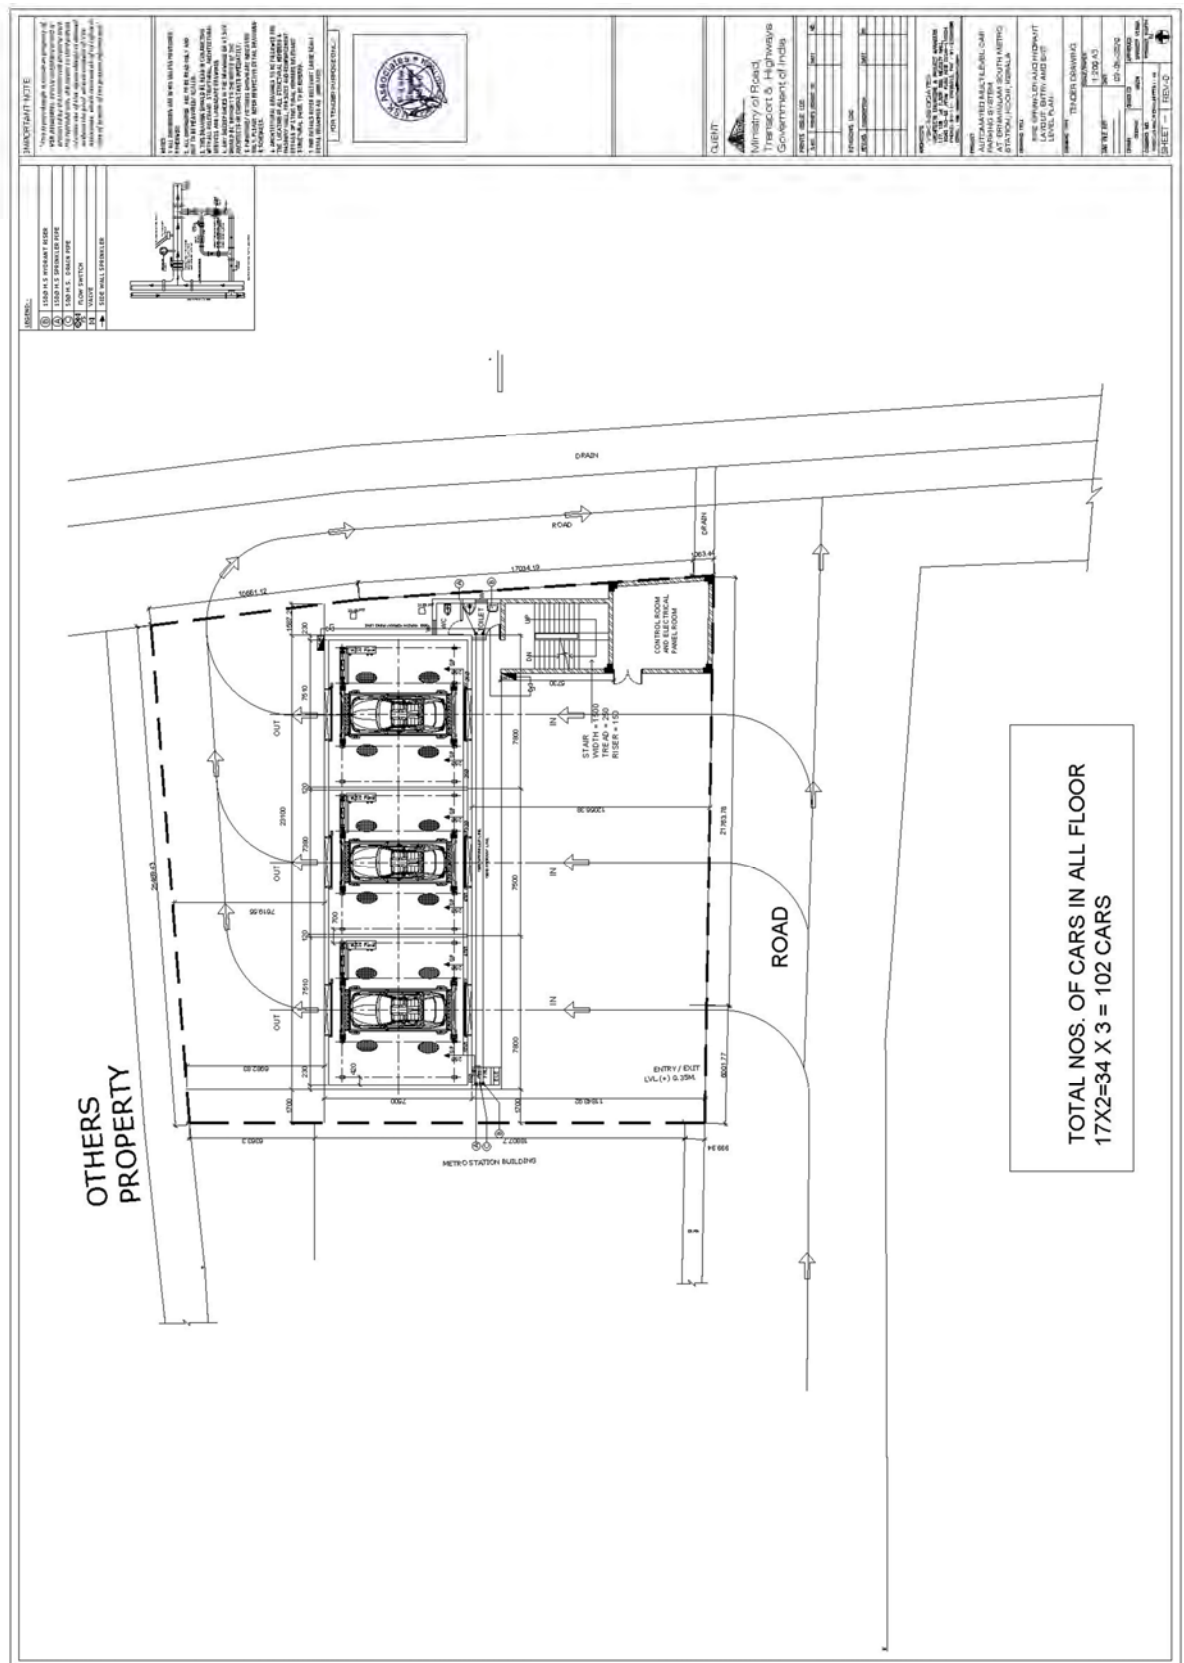

SECTION IV BIDDING FORMS: Schedules

ADDITIONAL APPENDIX C (DRAWINGS)











SECTION IV BIDDING FORMS: Schedules

ADDITIONAL APPENDIX C (DRAWINGS)

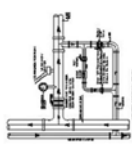

SECTION IV BIDDING FORMS: Schedules

ADDITIONAL APPENDIX C (DRAWINGS)

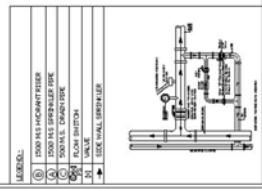

SECTION IV BIDDING FORMS: Schedules

ADDITIONAL APPENDIX C (DRAWINGS)

